




This project record document, drawings and specifications, have been prepared on the basis of data compiled and furnished by others. Roy E. Colbert, Architect, will not be responsible for errors or omissions resulting from that data being incorporated into this document. These drawings and specifications, and the incorporated ideas and designs, constitute an instrument of professional service and are the sole property of Roy E. Colbert, Architect. These documents in whole, or in part, shall not be used for any other project without the written authorization of Roy E. Colbert, Architect.

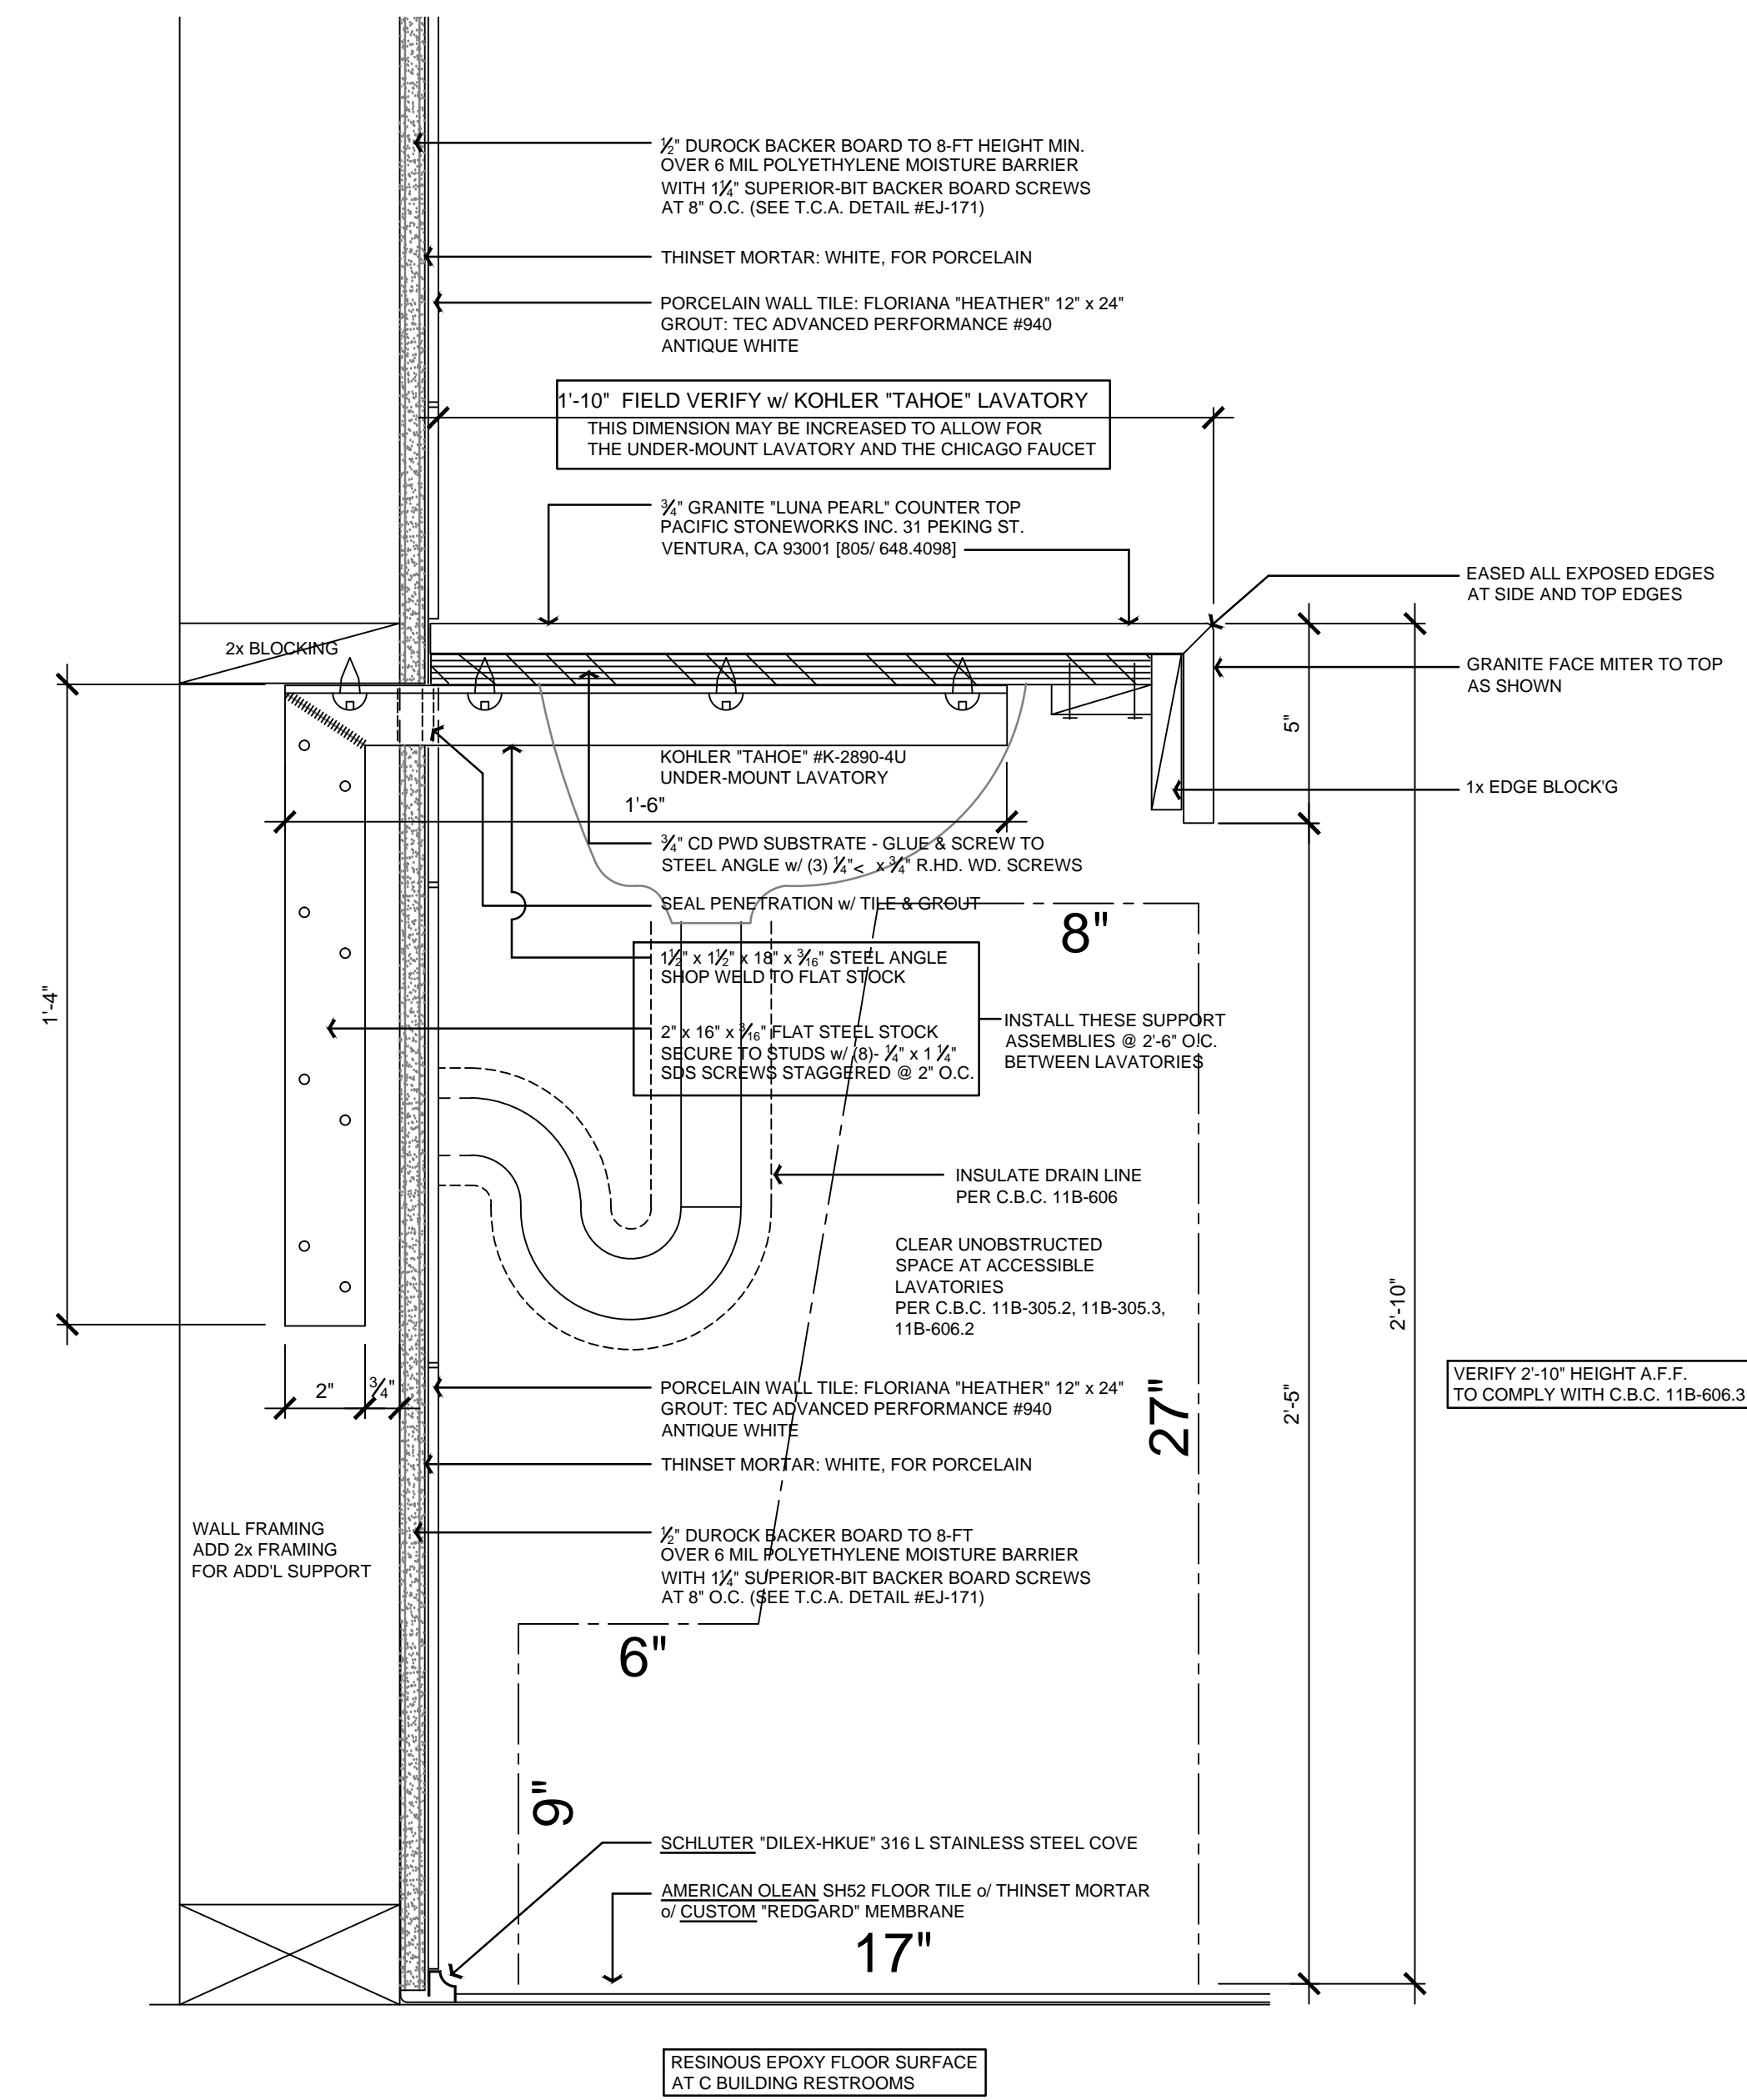


4 H.C. COUNTER TOP SUPPORT DTL - TYPICAL
SCALE: 3" = 1'-0"

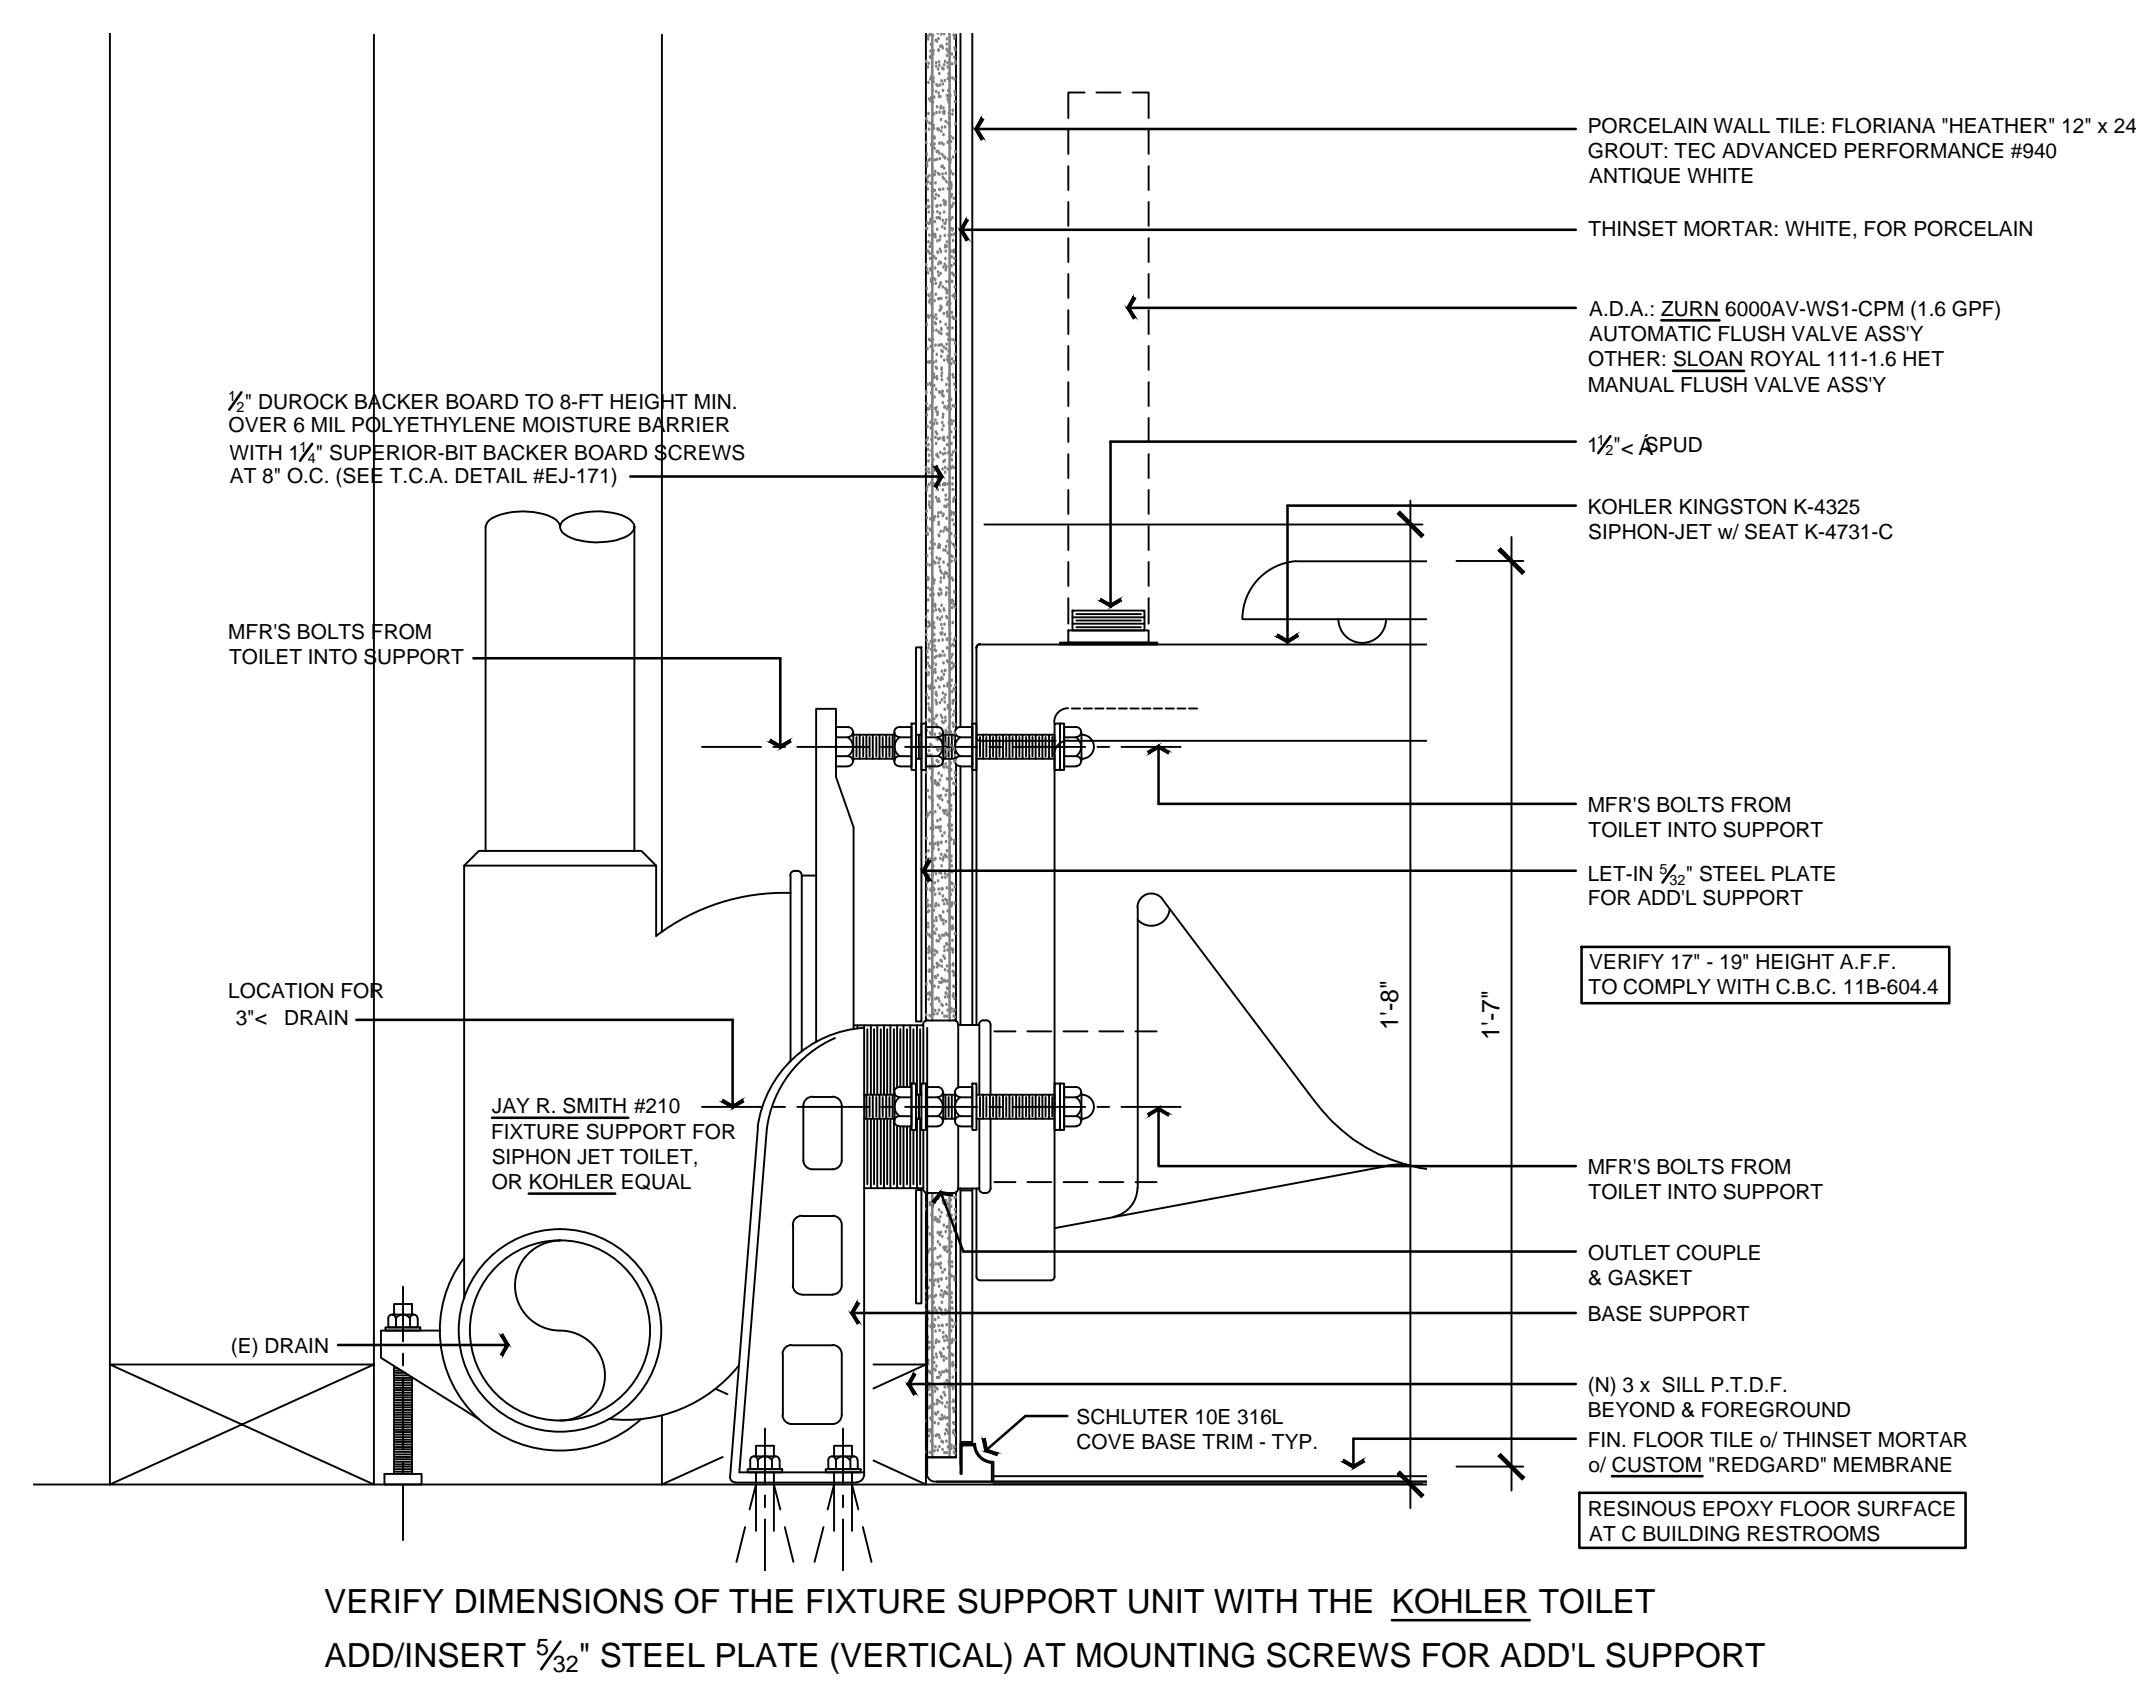

1 WALL HUNG TOILET FIXTURE SUPPORT - TYPICAL
SCALE: 3" = 1'-0"

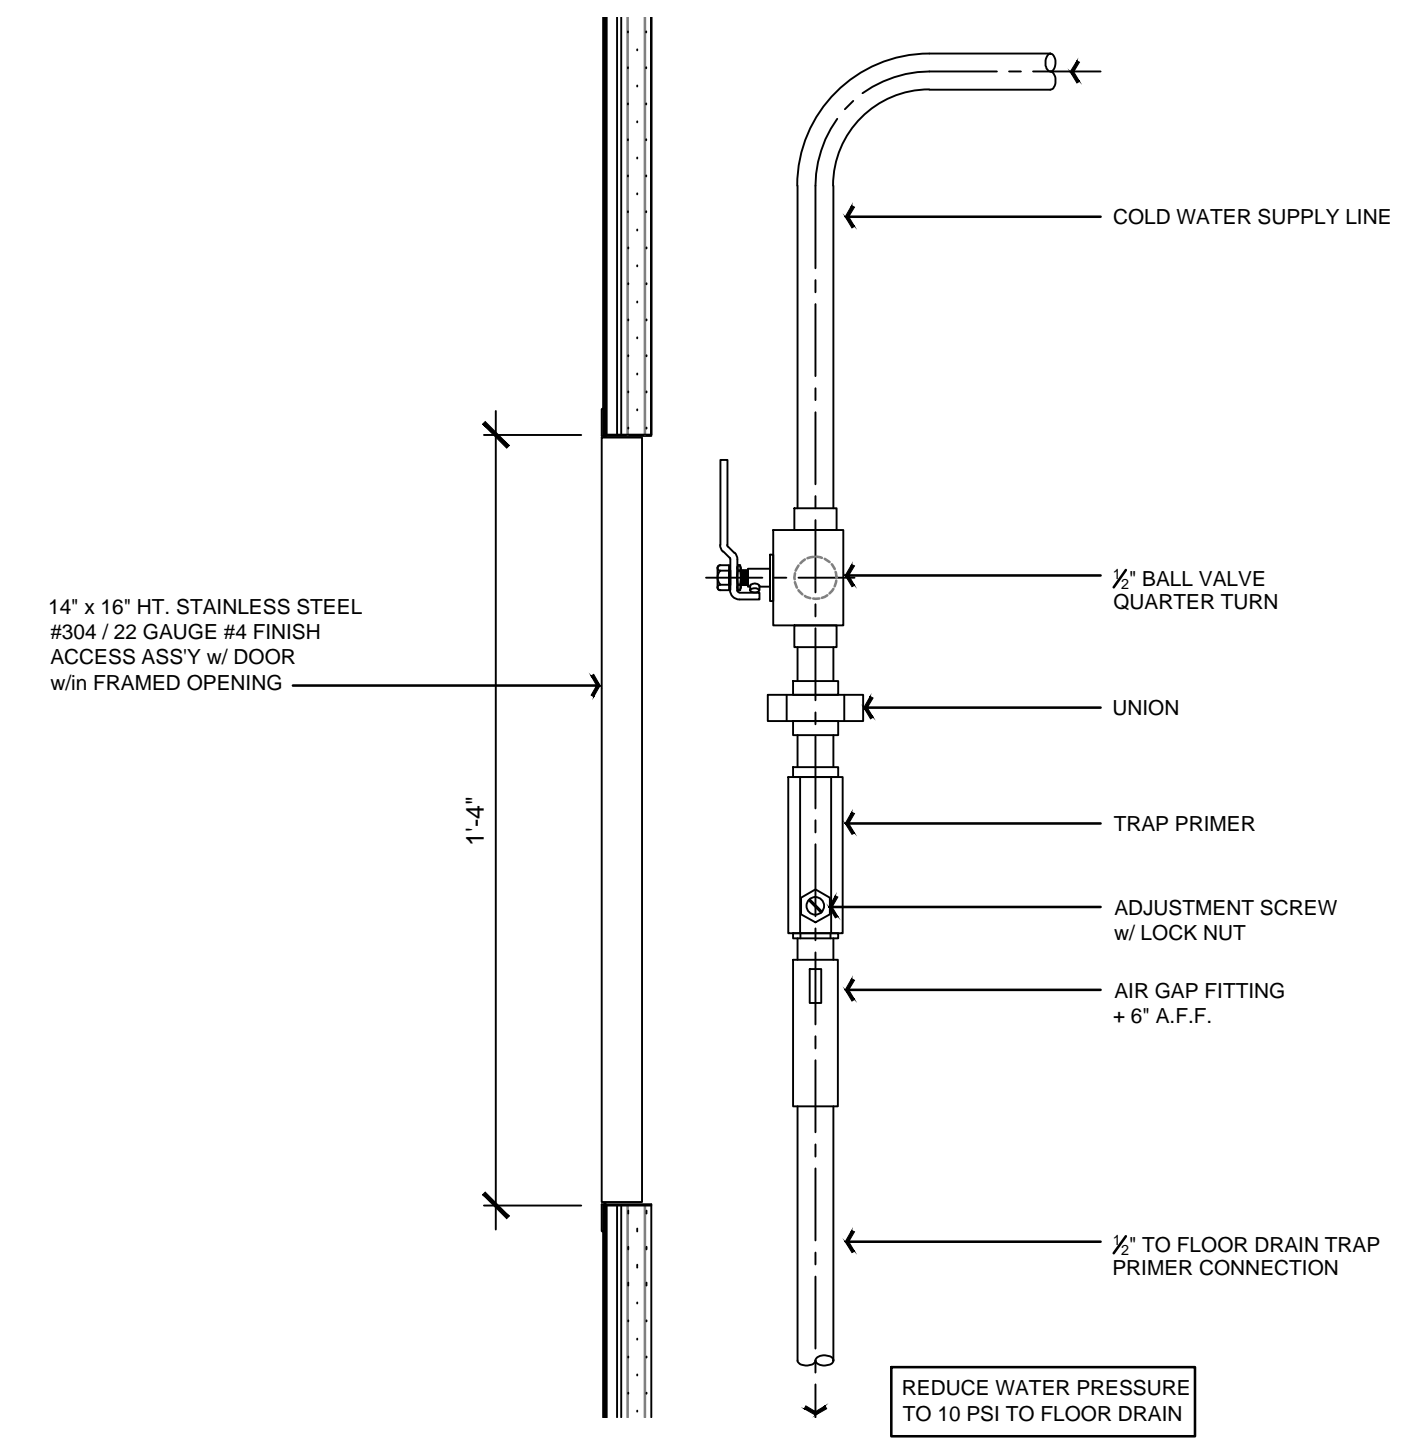

2 TRAP PRIMER DETAIL
SCALE: 3" = 1'-0"

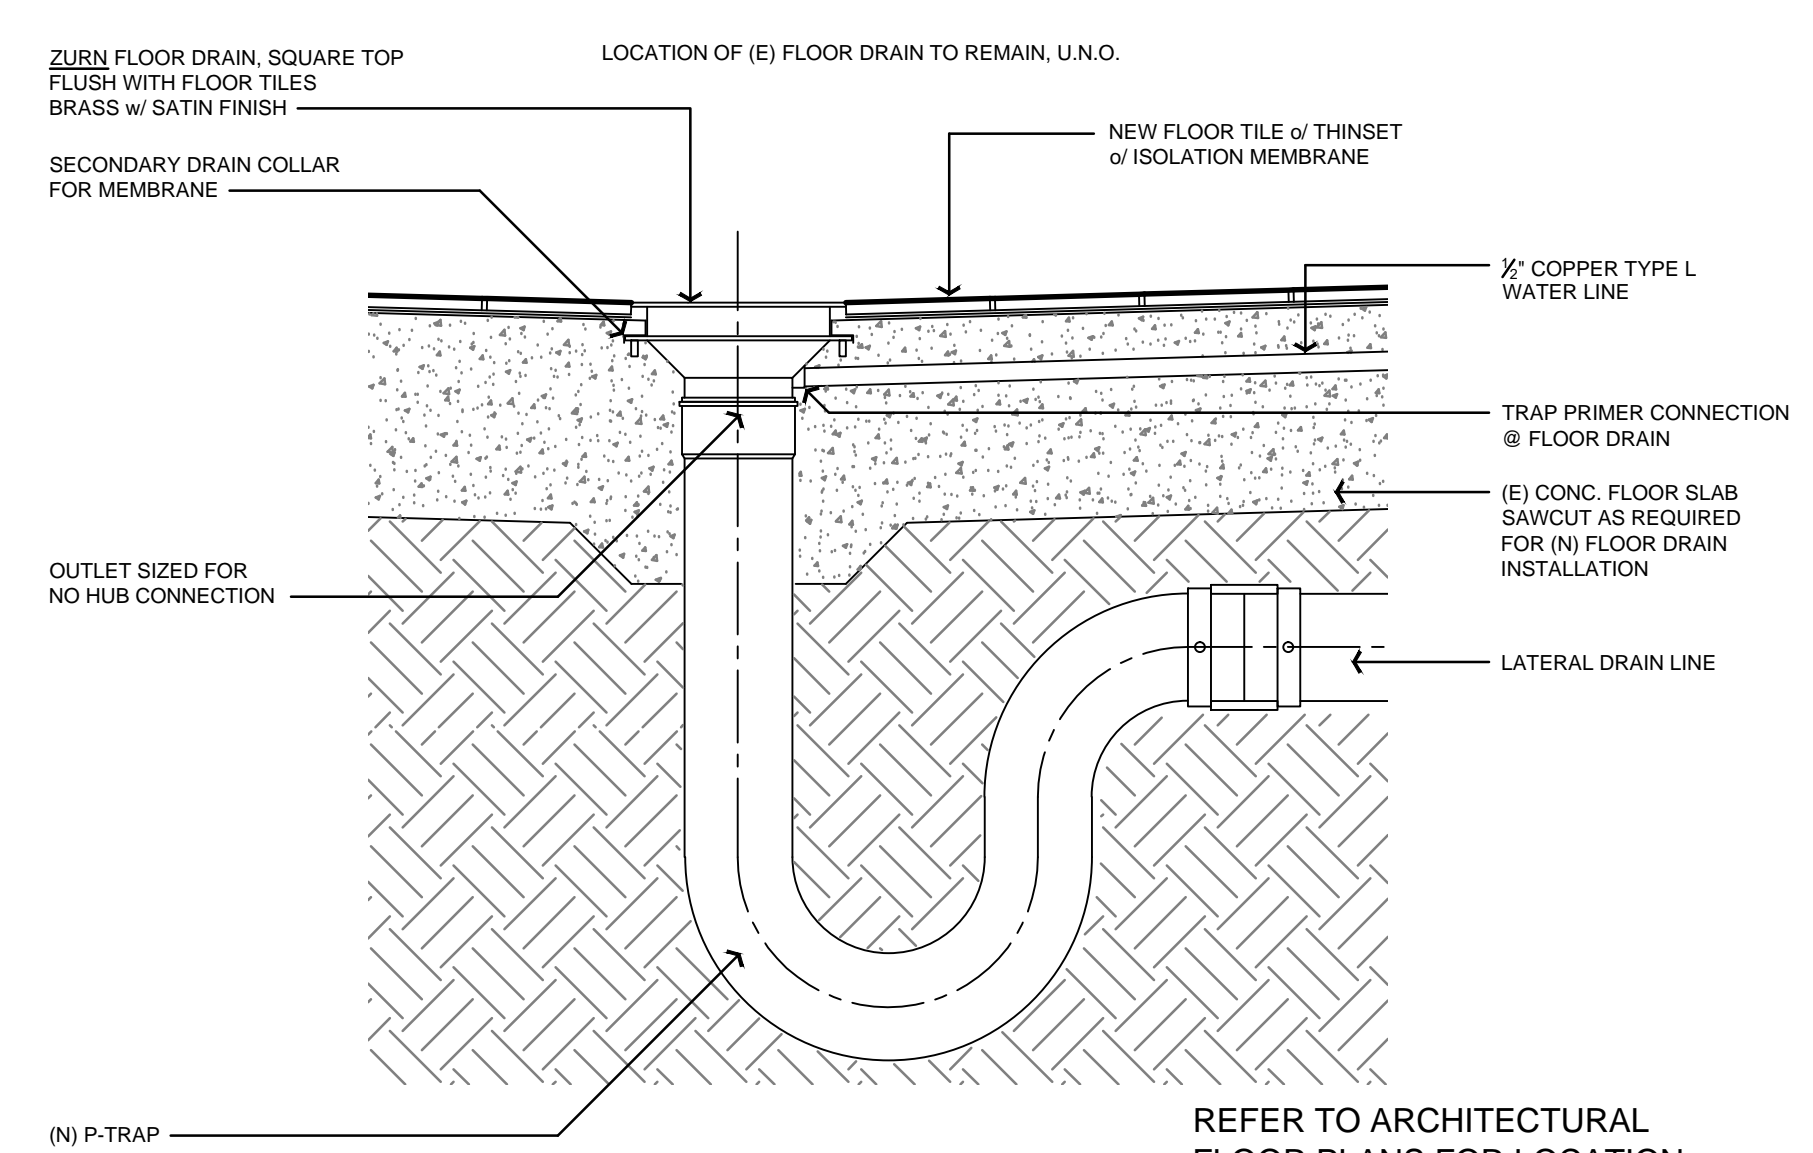

3 FLOOR DRAIN DETAIL
SCALE: 3" = 1'-0"

THIS PLAN IS BASED UPON DATA COMPILED AND FURNISHED BY OTHERS.


REVISIONS	DATE	BY
△	15 JUL 16	REC
△	30 AUG 16	REC

ROY E COLBERT

ARCHITECTURE
PLANNING
DESIGN

353 SAN JON ROAD
VENTURA, CA 93001

805 / 650 9590 PH
805 / 650 9589 FX
rcolb@sbcglobal.net

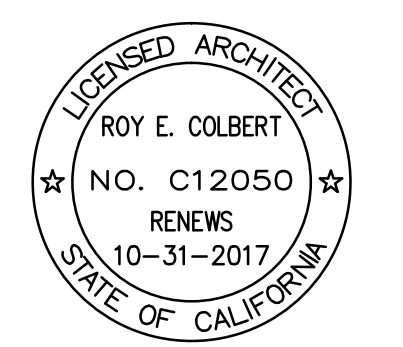

This project has been designed by me, or under my direct supervision.

VENTURA COUNTY
COMMUNITY
COLLEGE DISTRICT

VENTURA COLLEGE
4667 Telegraph Road
Ventura, CA 93003

C: GYMNASIUM
MEN & WOMEN
RESTROOMS
RENOVATION

PROJECT DIRECTORY

- SOILS ENGINEER / SEPTIC SYSTEM:
XXXX
- CIVIL ENGINEER:
XXXX
- STRUCTURAL ENGINEER:
XXXX
- ELECTRICAL ENGINEER:
LUCCI & ASSOCIATES
805/389.6520
- MECHANICAL ENGINEER:
A/E GROUP
805/653.1722
- LANDSCAPE ARCHITECT:
XXXX
- WATER SYSTEM / FIRE PROTECTION SYSTEM:
XXXX

**AEC: EVENT CENTER
C: GYMNASIUM
RESTROOM
PLUMBING DETAILS**

SHEET NAME

DATE

AS SHOWN

SCALE

C15 - 010

PROJECT

C15-010.C: P-3 00
SHEET NUMBER OF SHEETS

ISSUED FOR CONSTRUCTION