


PROJECT

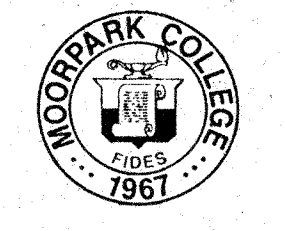

MOORPARK COLLEGE
PERFORMING ARTS CENTER

CLIENT

VENTURA COUNTY
 COMMUNITY COLLEGE DISTRICT

71 Day Road
 Ventura, California 93003

ACOUSTICAL ENGINEERS

McKAY, CONANT, BROOK, INC.
 5655 Lindero Canyon Road
 Suite 325
 Westlake Village, California 91362
 PHONE: (818) 991-9300


THEATER CONSULTANT

LANDRY & BOGAN
 2513 Charleston Road, Suite B
 Mountain View, California 94043
 PHONE: (415) 969-5195

U.S.A. SUBMITTAL #1 NOV. 22 1991

REVISIONS


SIGNATURE

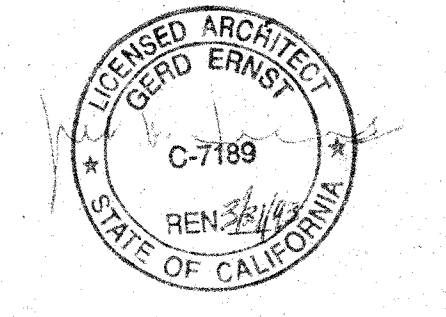


U.S.A. APPROVAL

STATE FIRE MARSHALL

ACCESS COMPLIANCE

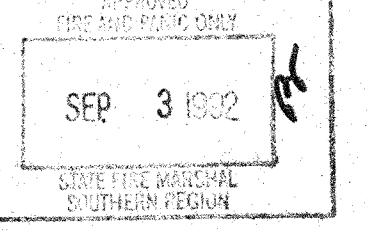

STRUCTURAL SAFETY

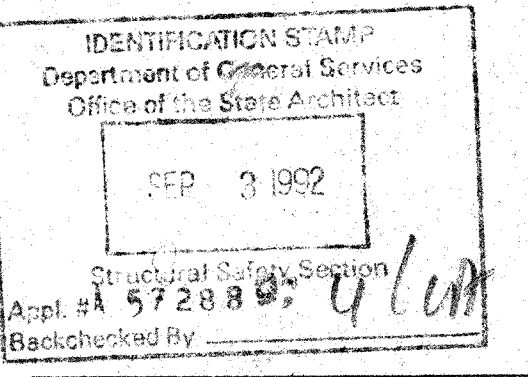

SHEET TITLE

BASEMENT FLOOR PLAN

CHECKED BY


APPROVED BY


JOB NO.

1149.01

DATE

M2.01

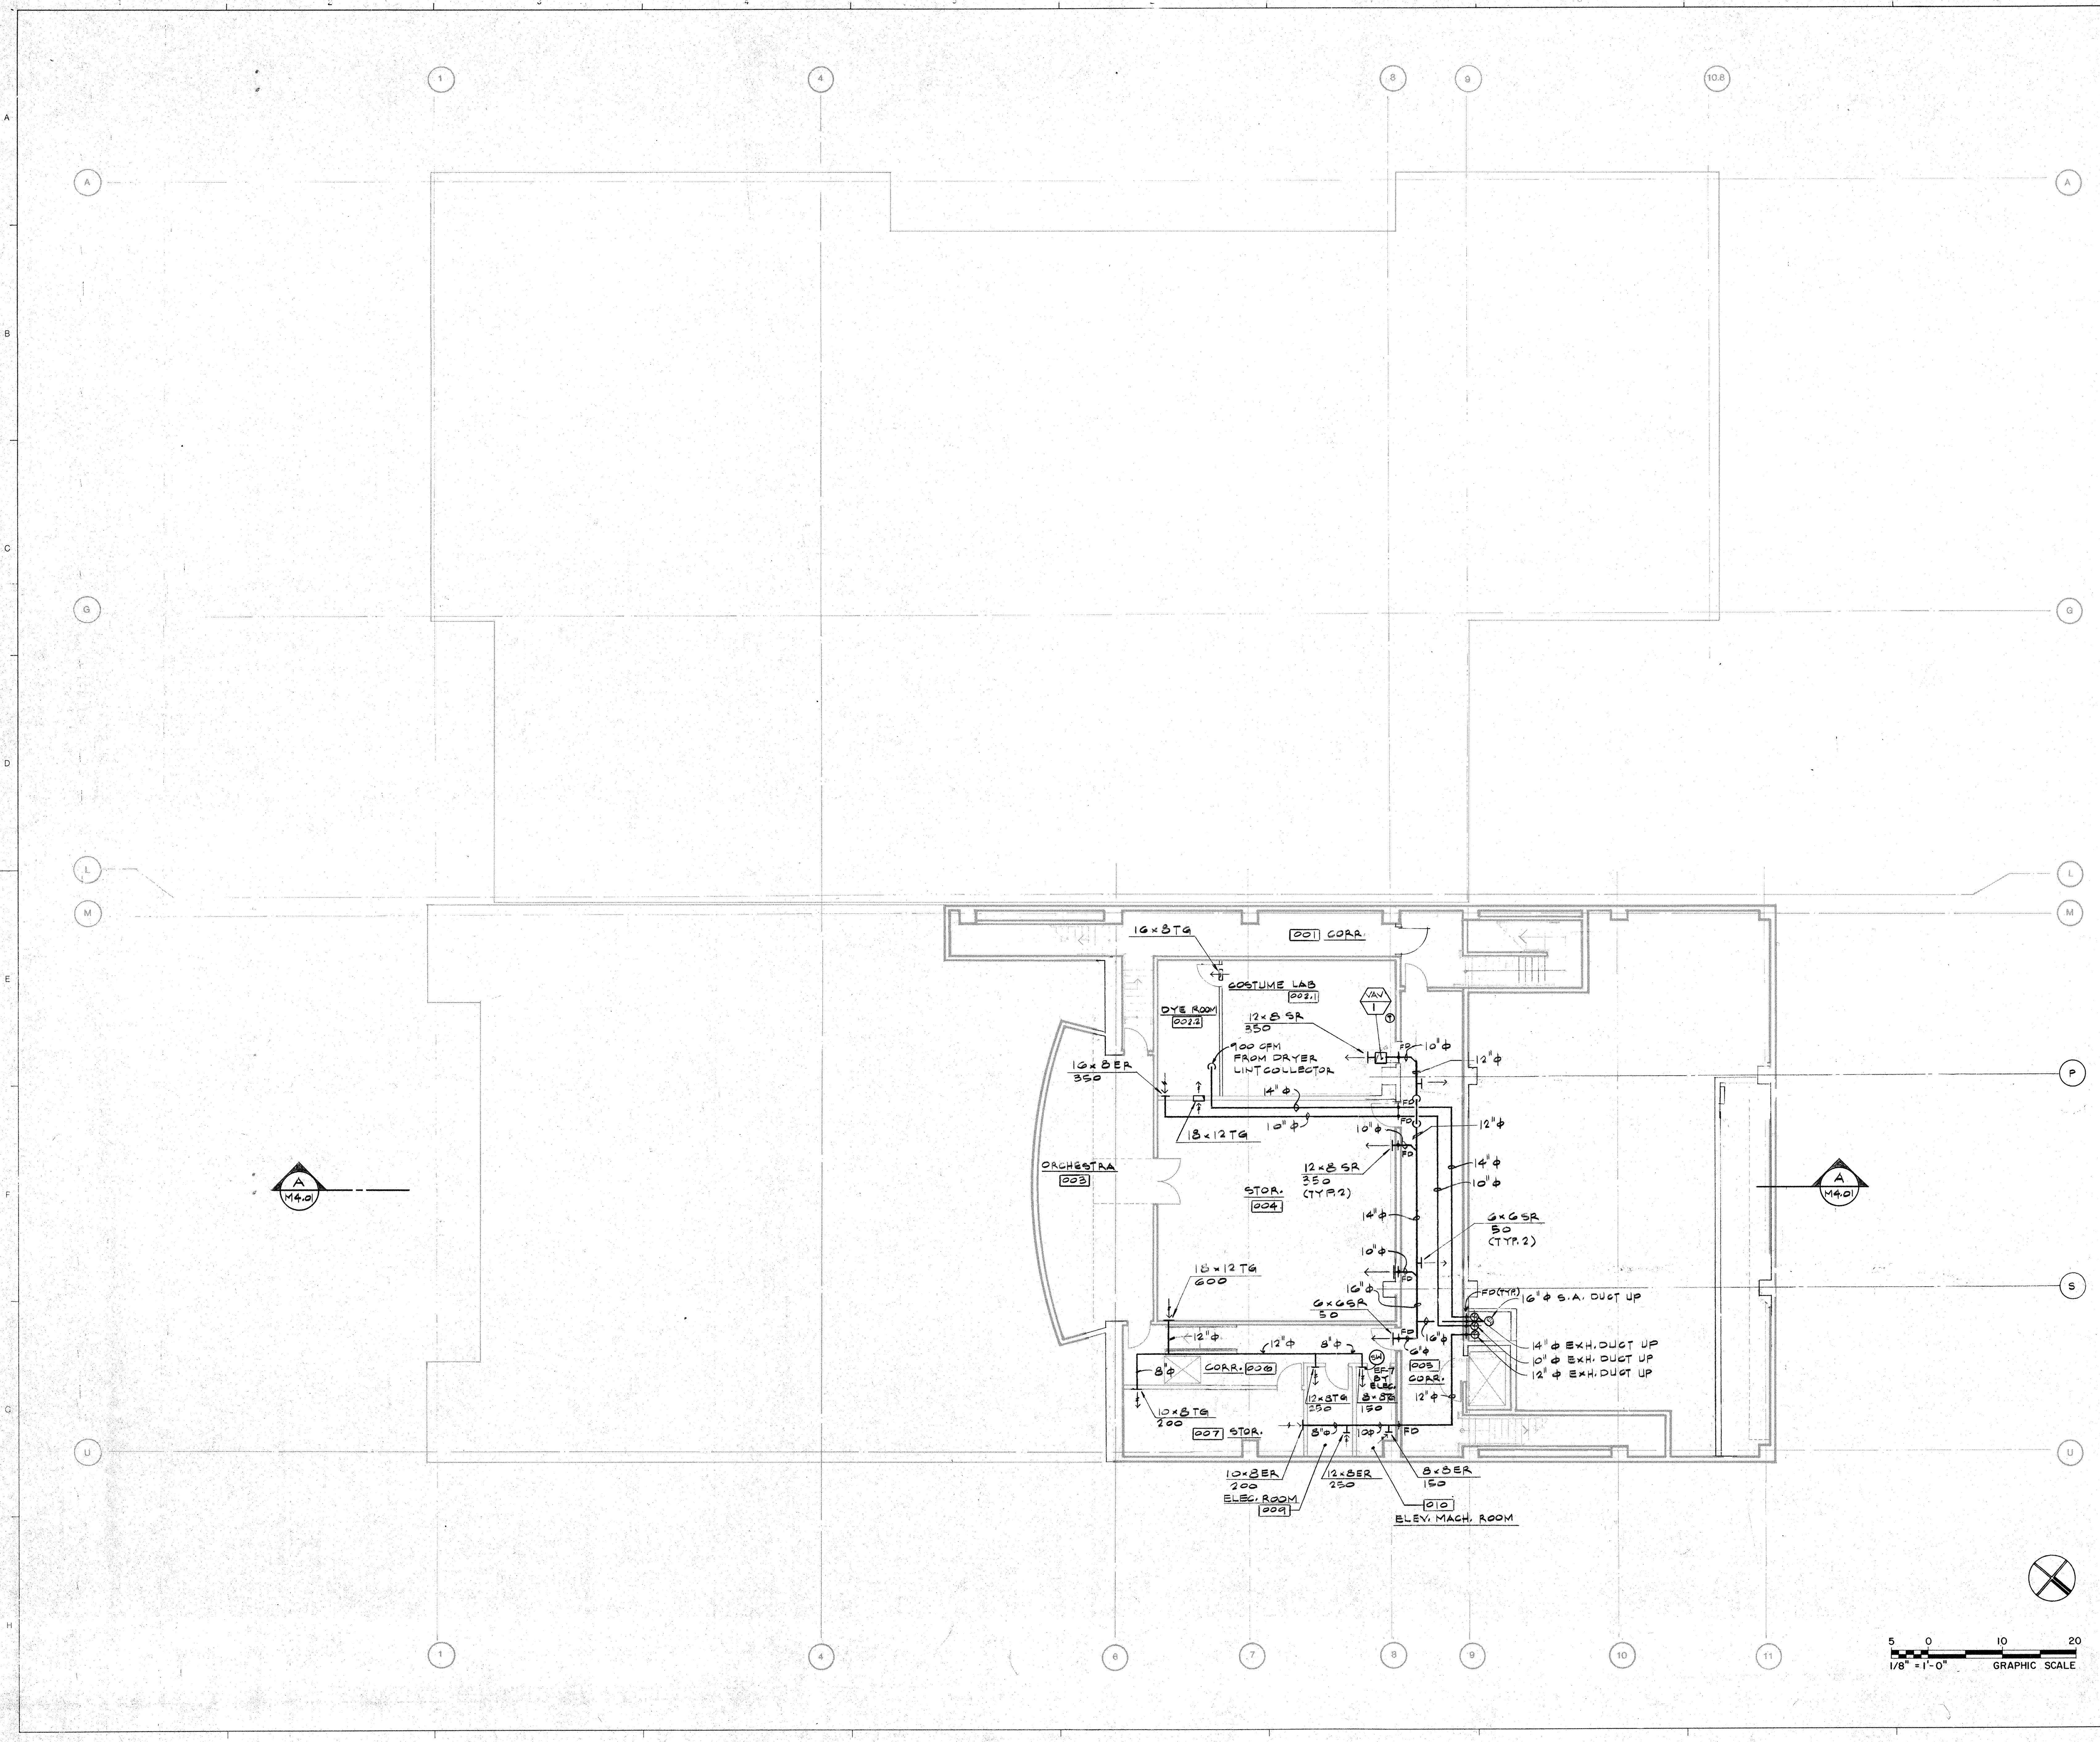

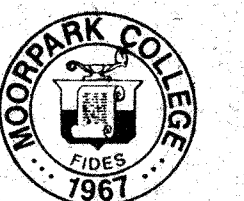


MOORPARK COLLEGE PERFORMING ARTS CENTER

CLIENT
 VENTURA COUNTY
 COMMUNITY COLLEGE DISTRICT
 71 Day Road
 Ventura, California 93003

ACOUSTICAL ENGINEERS
 McKay, Conant, Brook, Inc.
 5655 Lindero Canyon Road
 Suite 325
 Westlake Village, California 91362
 PHONE: (818) 991-9300

THEATER CONSULTANT
 LANDRY & BOGAN
 2513 Charleston Road, Suite B
 Mountain View, California 94043
 PHONE: (415) 909-5195

ROOM NUMBERS	ROOM NAMES
100	DRAMA LAB
101	TICKET BOOTH
102	VESTIBULE
103	OFFICE
104	VESTIBULE
105	STORAGE
106	VESTIBULE
107	DANCE CLASS ROOM
108	OFFICE
109	LOCKER/W.C.
110	STORAGE
111	STORAGE
112	JANITOR CLOSET
113	STORAGE
114	PRACTICE ROOM
115	ELECTRIC ROOM
116	CORRIDOR
117	OFFICE
118	CLASS ROOM
119	SQUAD ROOM
120	VIDEO ROOM
122	SPEECH LIBRA. PRACTICE RM
123	OFFICE
124	OFFICE
125	OFFICE
126	CONCESSION
127	LOBBY
128	CLASS ROOM
129	COSTUME STORAGE
130	CORRIDOR
131	WOMEN
132	WOMEN SHOWER/DRESSING
133	WOMEN LOCKER
134	MAKE-UP
135	MAKE-UP
136	MEN LOCKER
137	MEN
138	MEN SHOWER/DRESSING
139	OFFICE
140	MEETING ROOM
141	MEETING ROOM
142	OFFICE
143	CORRIDOR
144	ELEV. MACHINE ROOM
145	WORK ROOM
146	TELEPHONE ROOM
147	DIMMER BANK
148	SWITCHGEAR ELECT. RM
149	AUDITORIUM
150	BOX BOOM RIGHT
151	BOX BOOM LEFT
152	STAGE
153	CORRIDOR
154	SOBBER SHOP
155	OFFICE
156	TOOL CRIB
156A	FIRE ASSEMBLY ROOM
157	STORAGE
158	PAINT STORAGE
159	ORCHESTRA

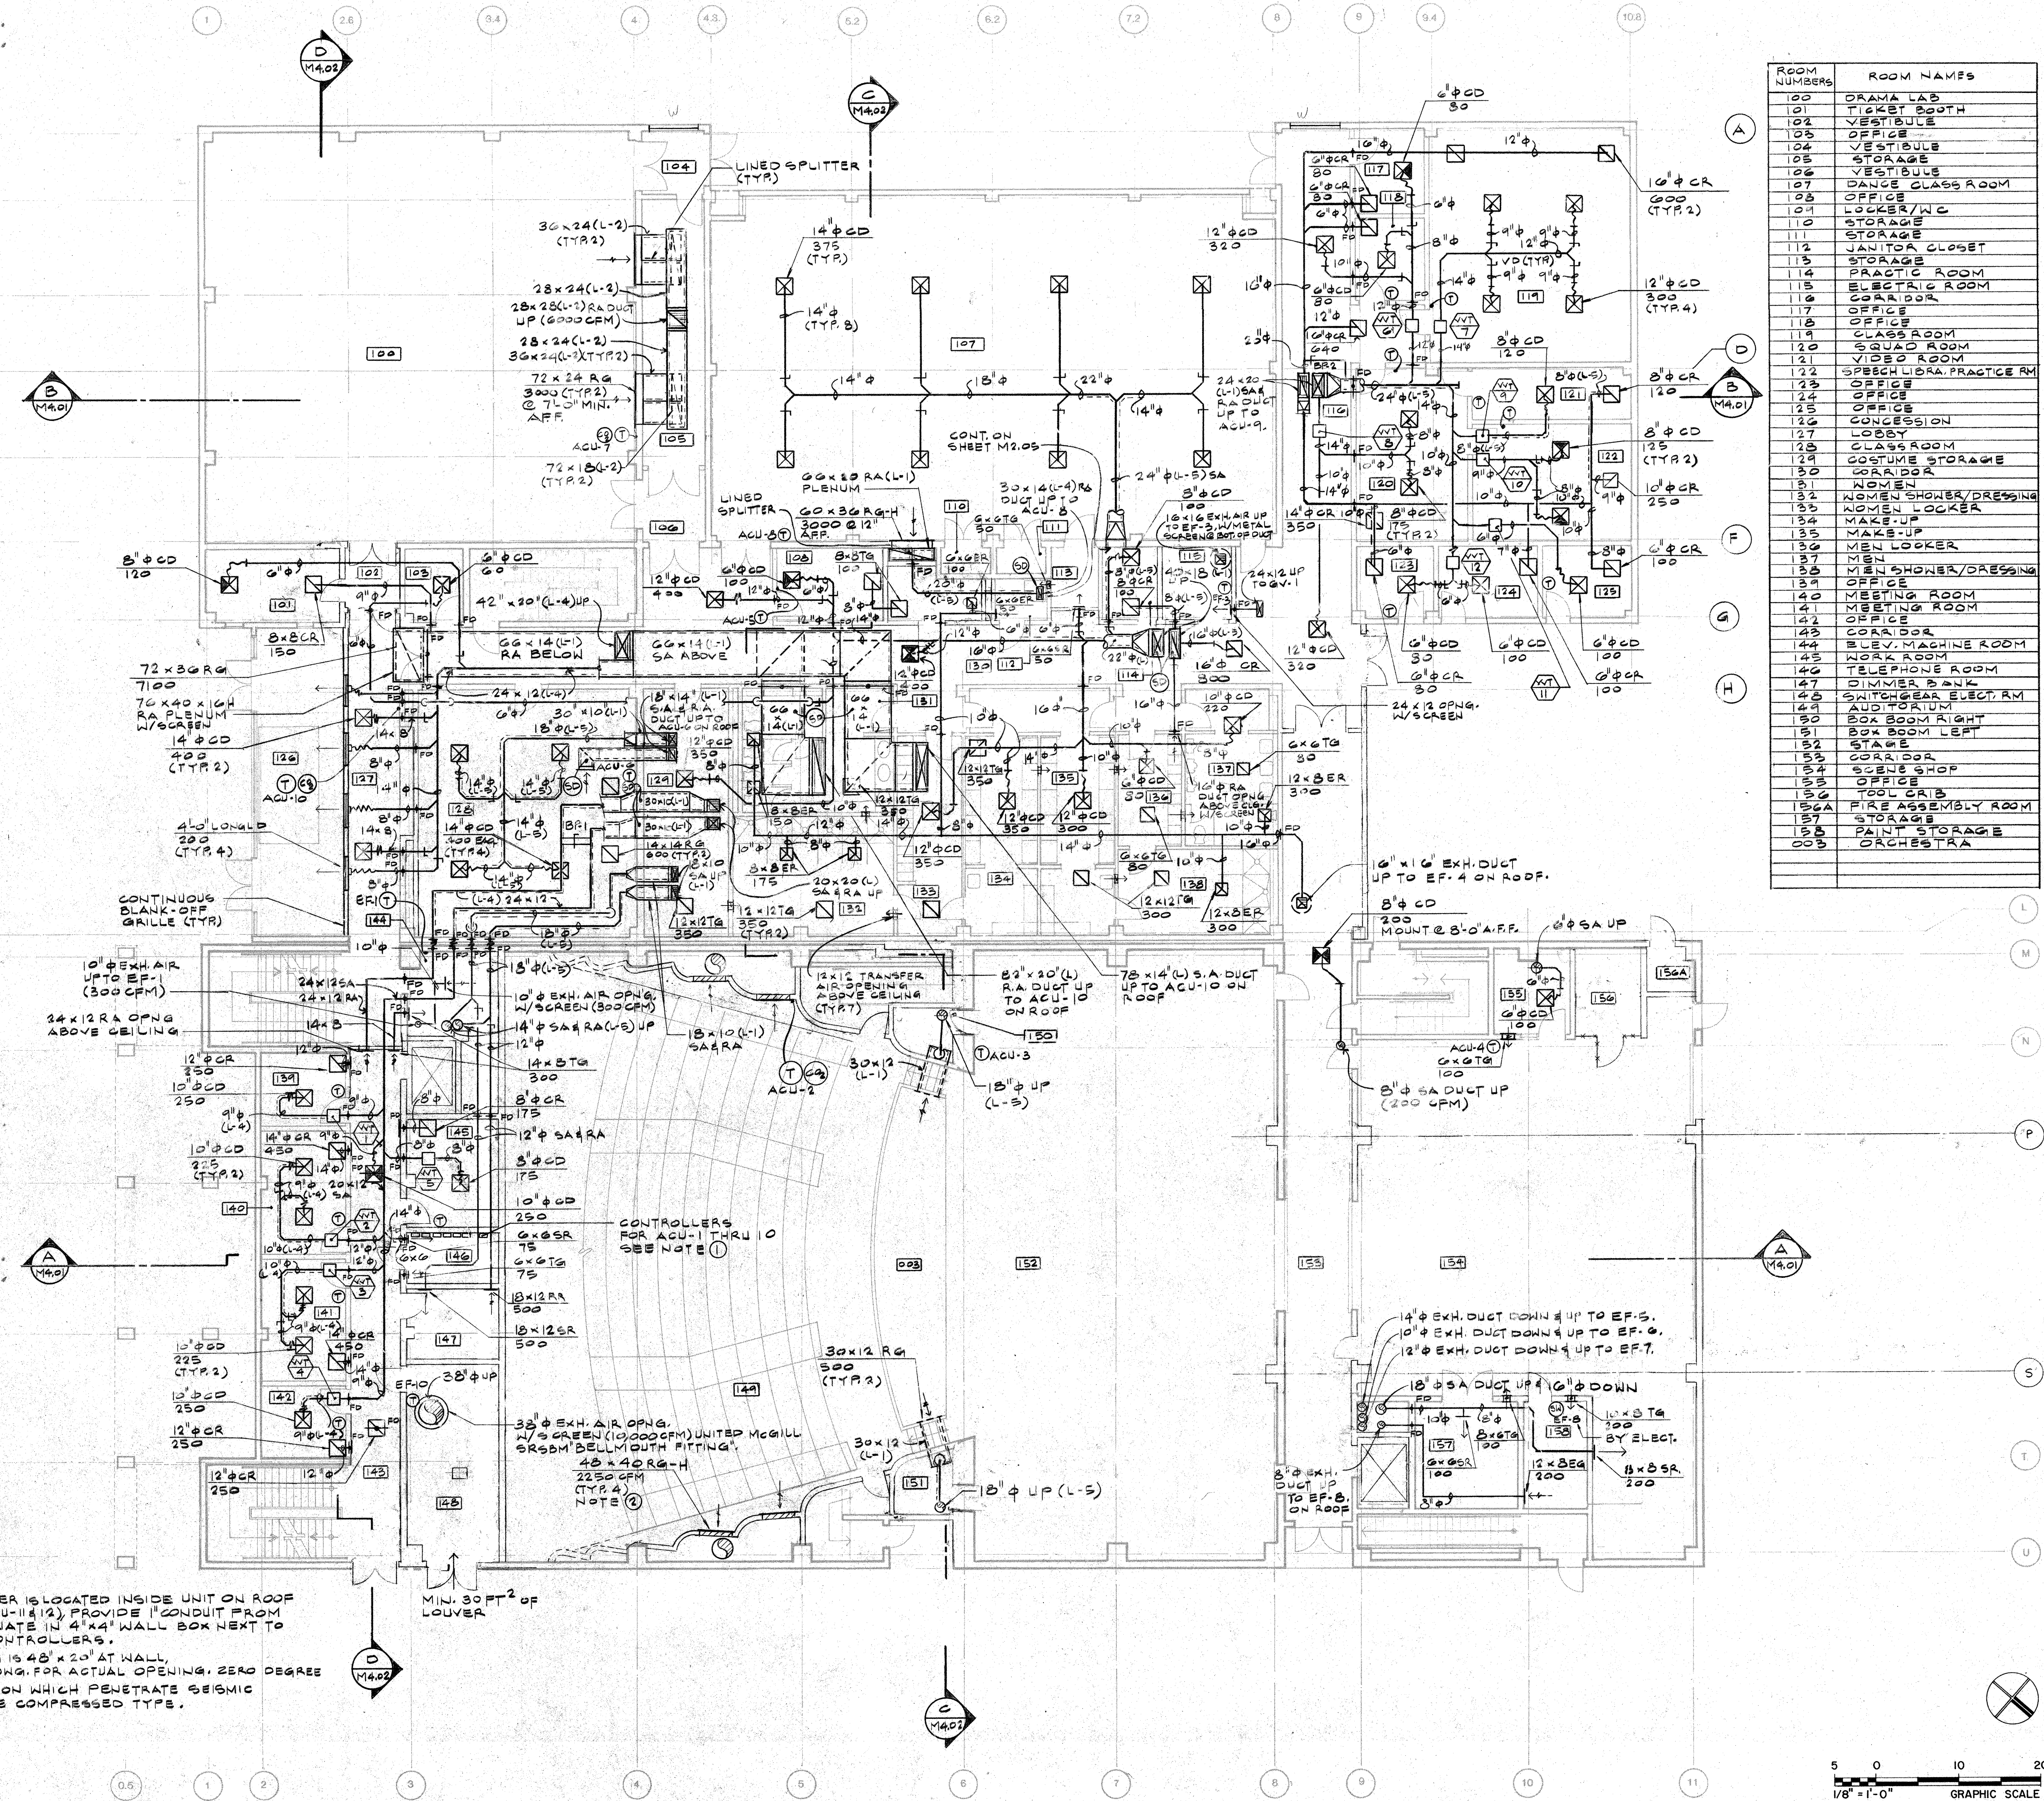


- NOTES:
- WHERE CONTROLLER IS LOCATED INSIDE UNIT ON ROOF EXCEPT FOR ACU-11(12) PROVIDE 1" CONDUIT FROM UNIT TO TERMINATE IN 4"x4" WALL BOX NEXT TO OTHER UNIT CONTROLLERS.
 - ACTUAL OPENING IS 48" x 20" AT WALL. SEE ARCHITECT DNG. FOR ACTUAL OPENING. ZERO DEGREE STRAIGHT THROUGH.
 - FLX. CONNECTION WHICH PENETRATES SEISMIC JOINT SHALL BE COMPRESSED TYPE.


O.S.A. SUBMITTAL #1 NOV. 22 1991

REVISIONS

SIGNATURE

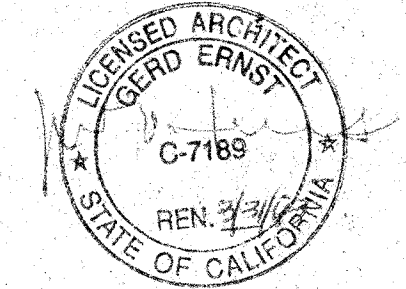

O.S.A. APPROVAL
 STATE FIRE MARSHALL ACCESS COMPLIANCE

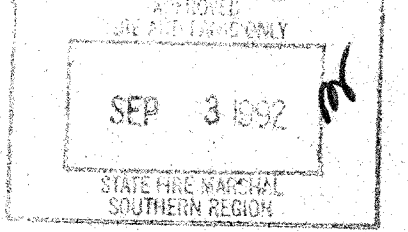

STRUCTURAL SAFETY


SHEET TITLE

GROUND LEVEL PLAN


CHECKED BY APPROVED BY

JOB NO. 1149.01

DATE

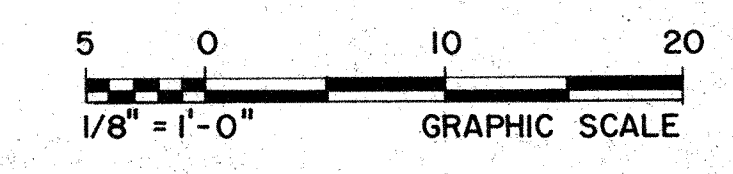

PROJECT

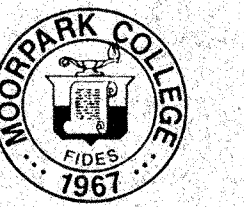

MOORPARK COLLEGE
 PERFORMING ARTS CENTER

CLIENT

VENTURA COUNTY
 COMMUNITY COLLEGE DISTRICT

71 Day Road
 Ventura, California 93003


ACOUSTICAL ENGINEERS

McKAY, CONANT, BROOK, INC.
 5655 Lindero Canyon Road
 Suite 325
 Westlake Village, California 91362
 PHONE: (818) 991-9300

THEATER CONSULTANT

LANDRY & BOGAN
 2513 Charleston Road, Suite B
 Mountain View, California 94043
 PHONE: (415) 969-5195


NOTES:
 ① FLEX. CONNECTION WHICH PENETRATE SEISMIC JOINT SHALL BE COMPRESSED TYPE.

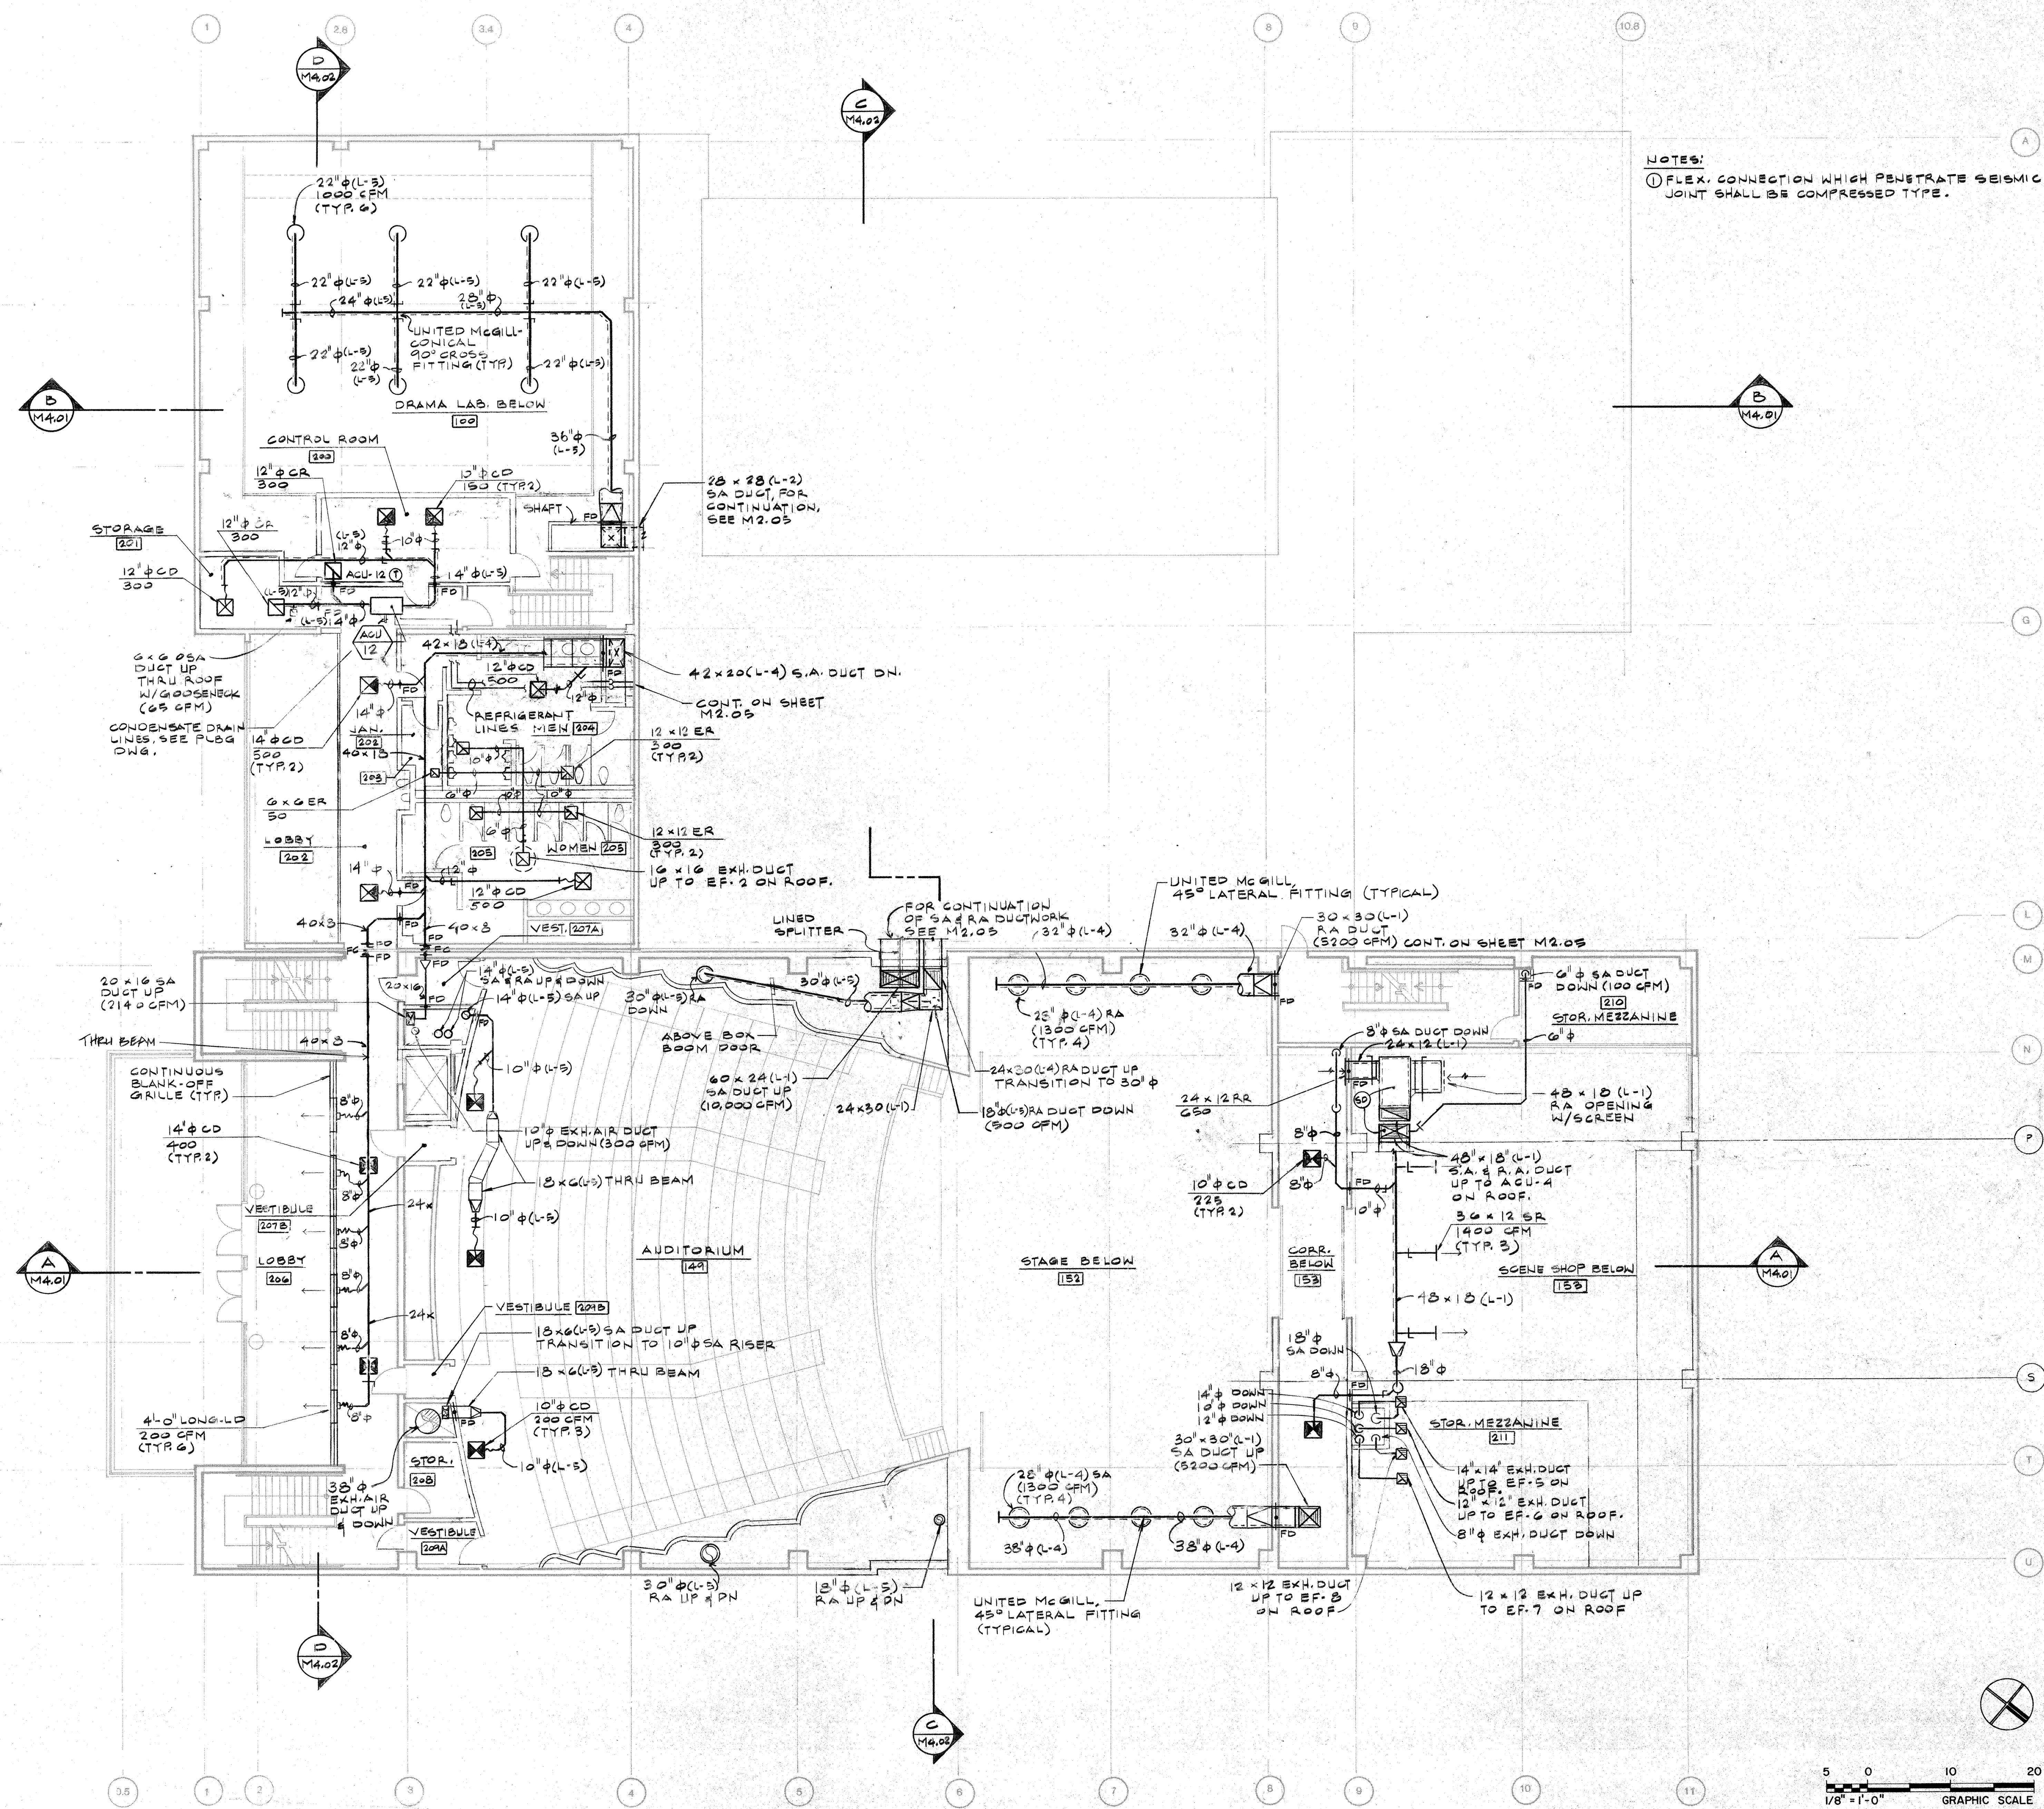

O.S.A. SUBMITAL #1 NOV. 22 1991


REVISIONS

SIGNATURE

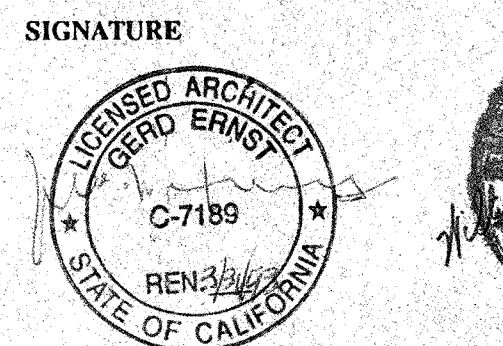


O.S.A. APPROVAL

STATE FIRE MARSHALL ACCESS COMPLIANCE

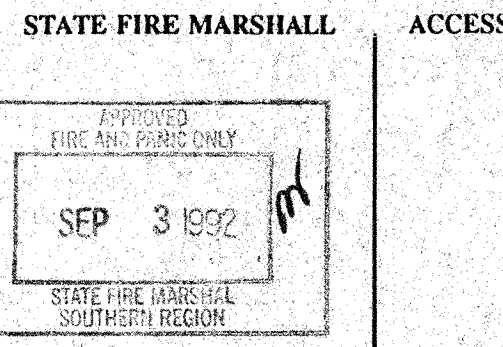

STRUCTURAL SAFETY

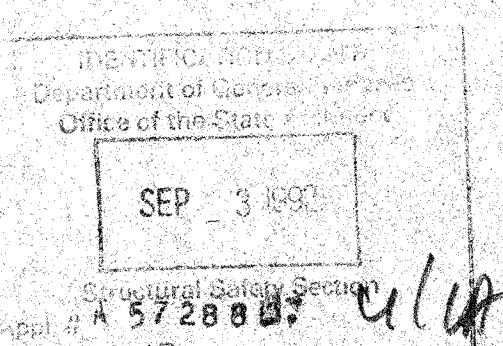


SHEET TITLE

LOBBY LEVEL PLAN


CHECKED BY APPROVED BY

JOB NO. **1149.01**

DATE

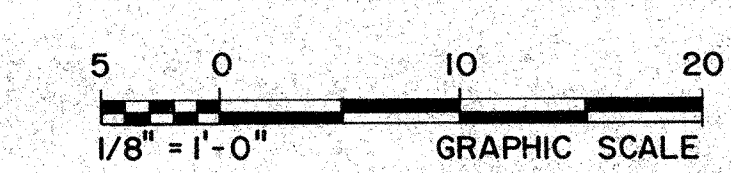

PROJECT

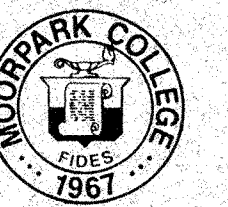

MOORPARK COLLEGE PERFORMING ARTS CENTER

CLIENT

VENTURA COUNTY
 COMMUNITY COLLEGE DISTRICT

71 Day Road
 Ventura, California 93003

ACOUSTICAL ENGINEERS

McKAY, CONANT, BROOK, INC.
 5655 Lindero Canyon Road
 Suite 325
 Westlake Village, California 91362
 PHONE: (818) 991-9300

THEATER CONSULTANT

LANDRY & BOGAN
 2513 Charleston Road, Suite B
 Mountain View, California 94043
 PHONE: (415) 969-5195

O.S.A. SUBMITTAL #1 NOV. 22 1991


REVISIONS

SIGNATURE




O.S.A. APPROVAL

STATE FIRE MARSHALL ACCESS COMPLIANCE

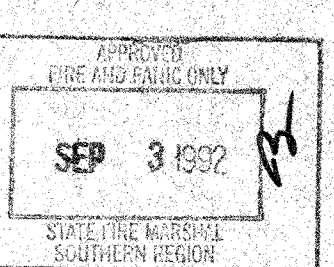

STRUCTURAL SAFETY

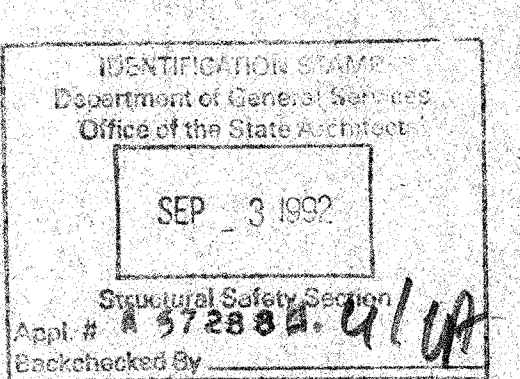

SHEET TITLE



UPPER LEVEL PLAN


CHECKED BY APPROVED BY

JOB NO. 1149.01

DATE

M2.04

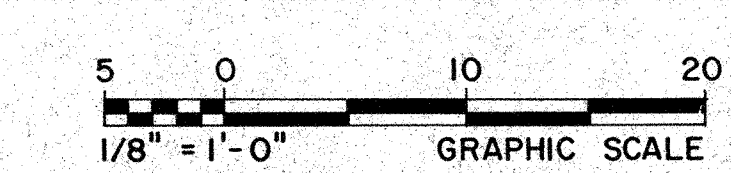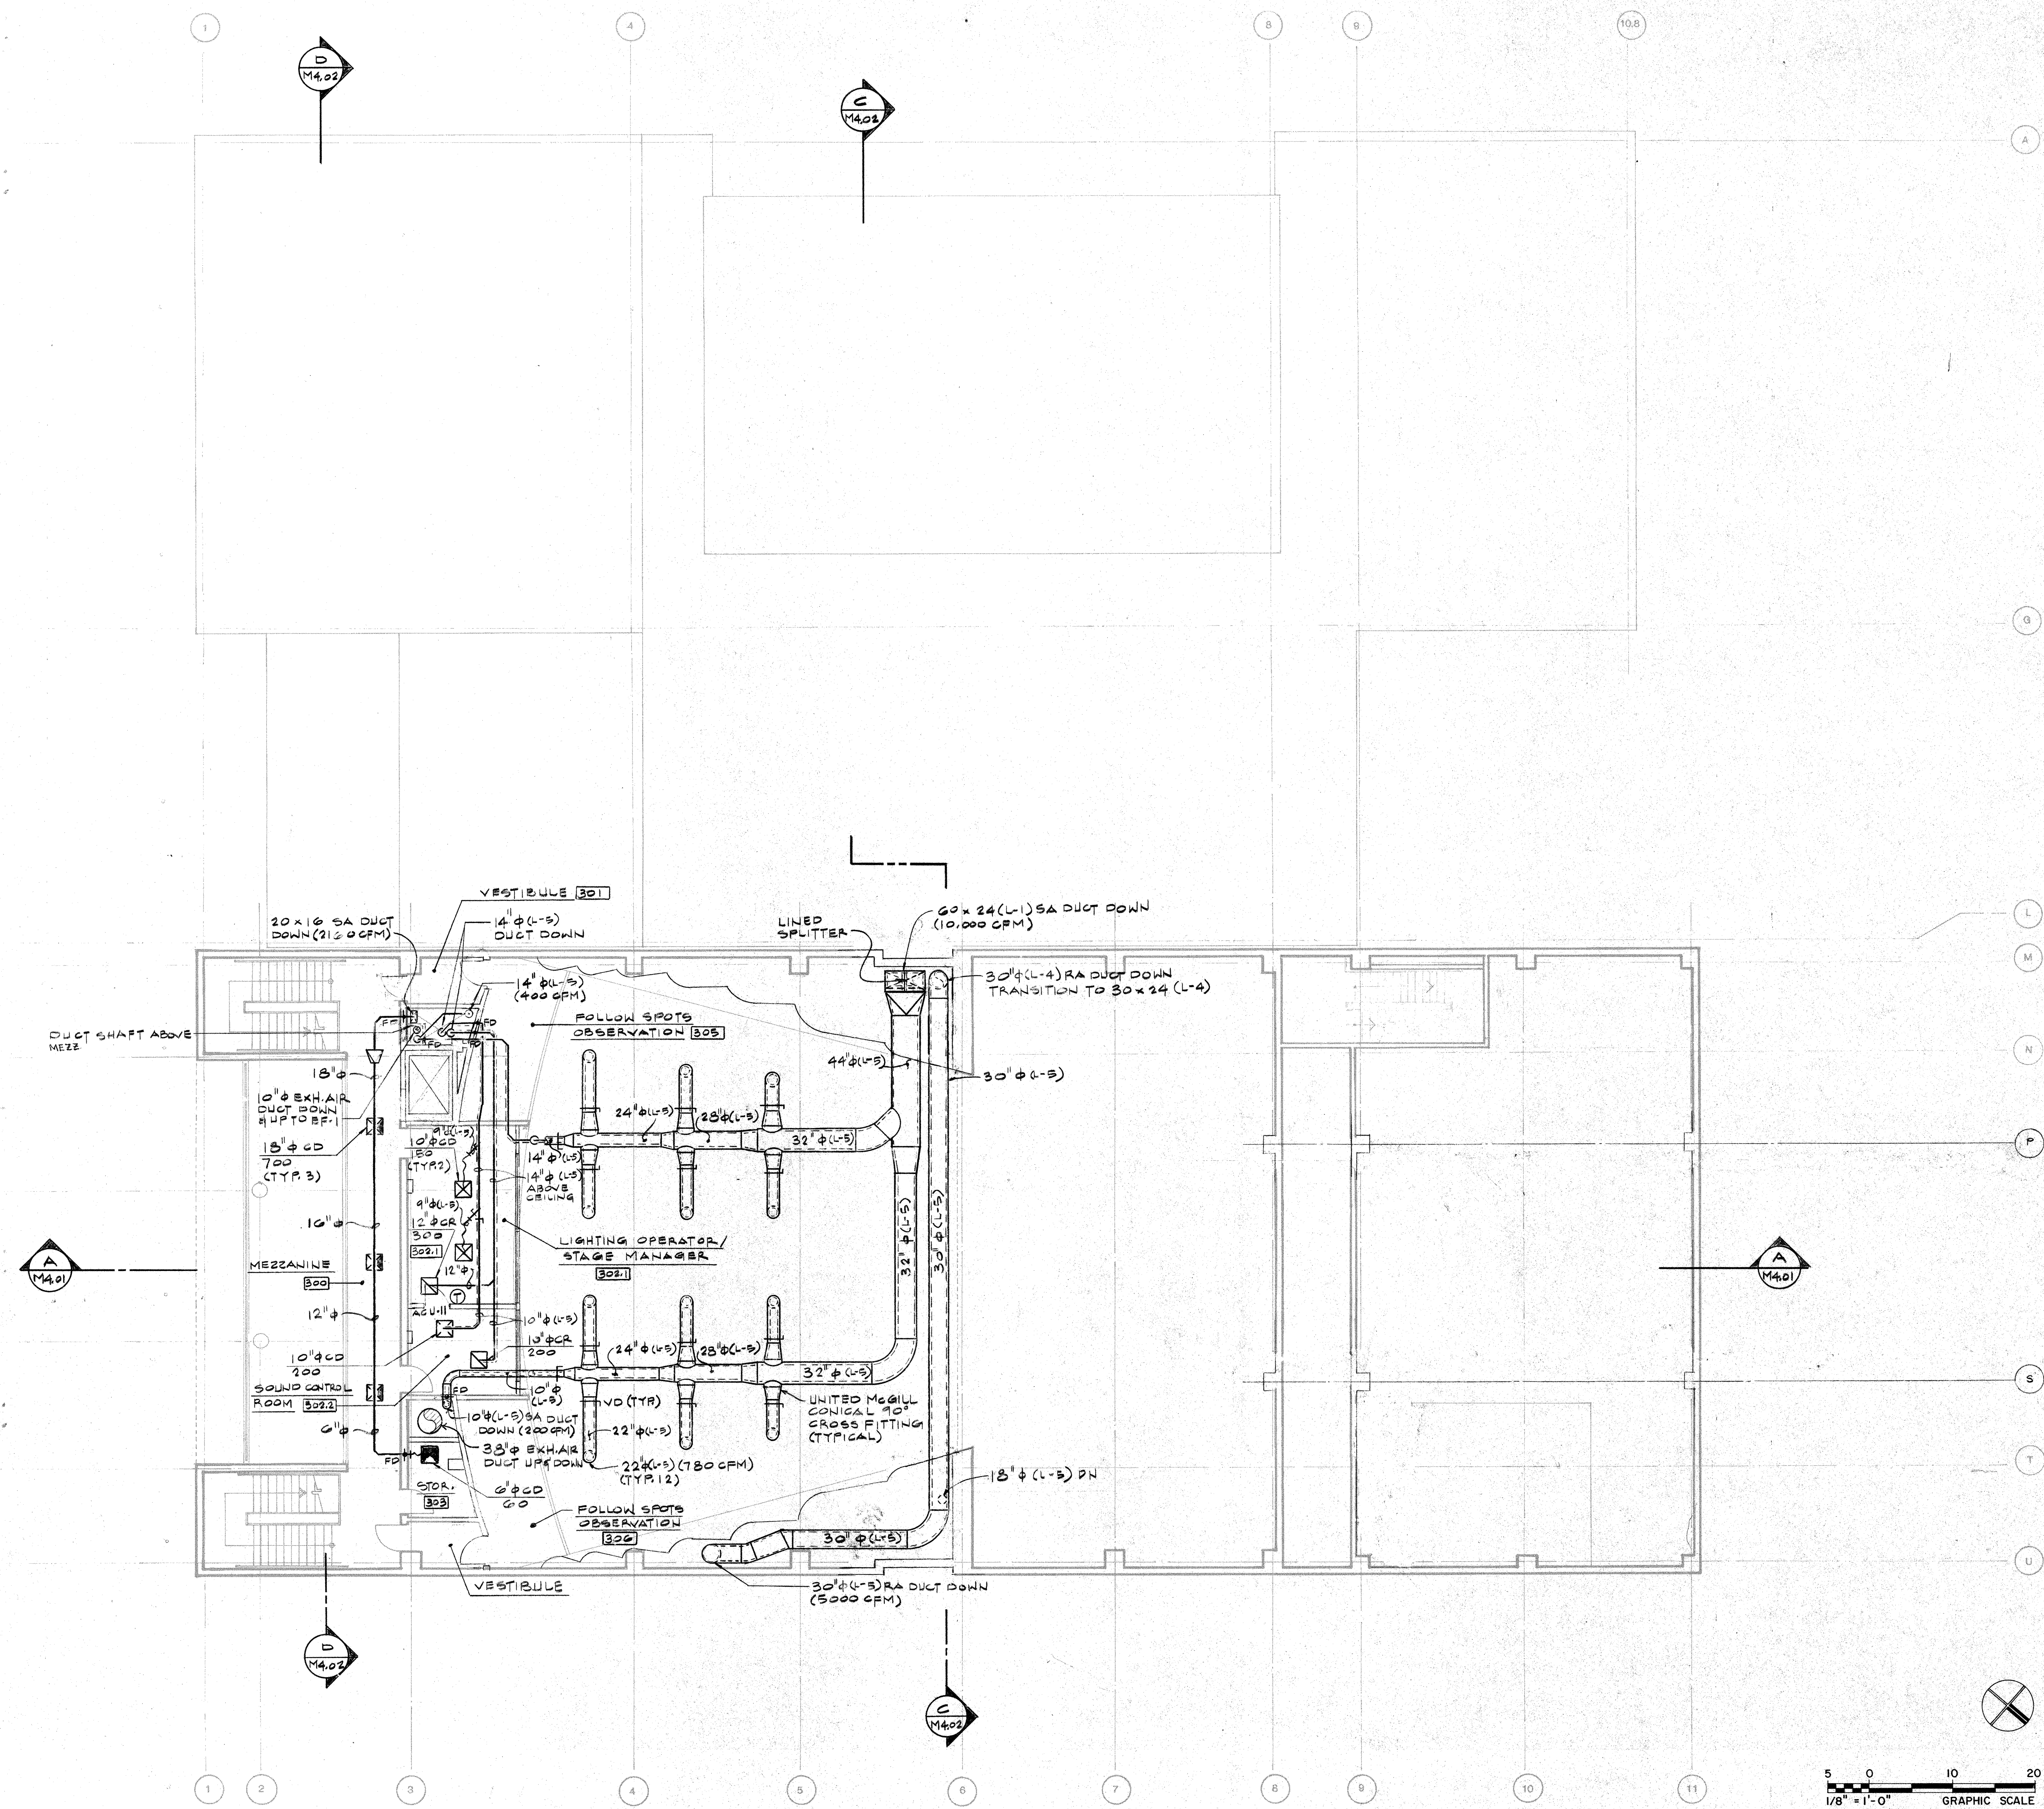

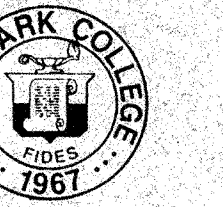

MOORPARK COLLEGE PERFORMING ARTS CENTER


CLIENT
 VENTURA COUNTY
 COMMUNITY COLLEGE DISTRICT
 71 Day Road
 Ventura, California 93003

ACOUSTICAL ENGINEERS

McKAY, CONANT, BROOK, INC.
 5655 Lindero Canyon Road
 Suite 325
 Westlake Village, California 91362
 PHONE: (818) 991-9300

THEATER CONSULTANT

LANDRY & HOGAN
 2513 Charleston Road, Suite B
 Mountain View, California 94033
 PHONE: (415) 969-5195

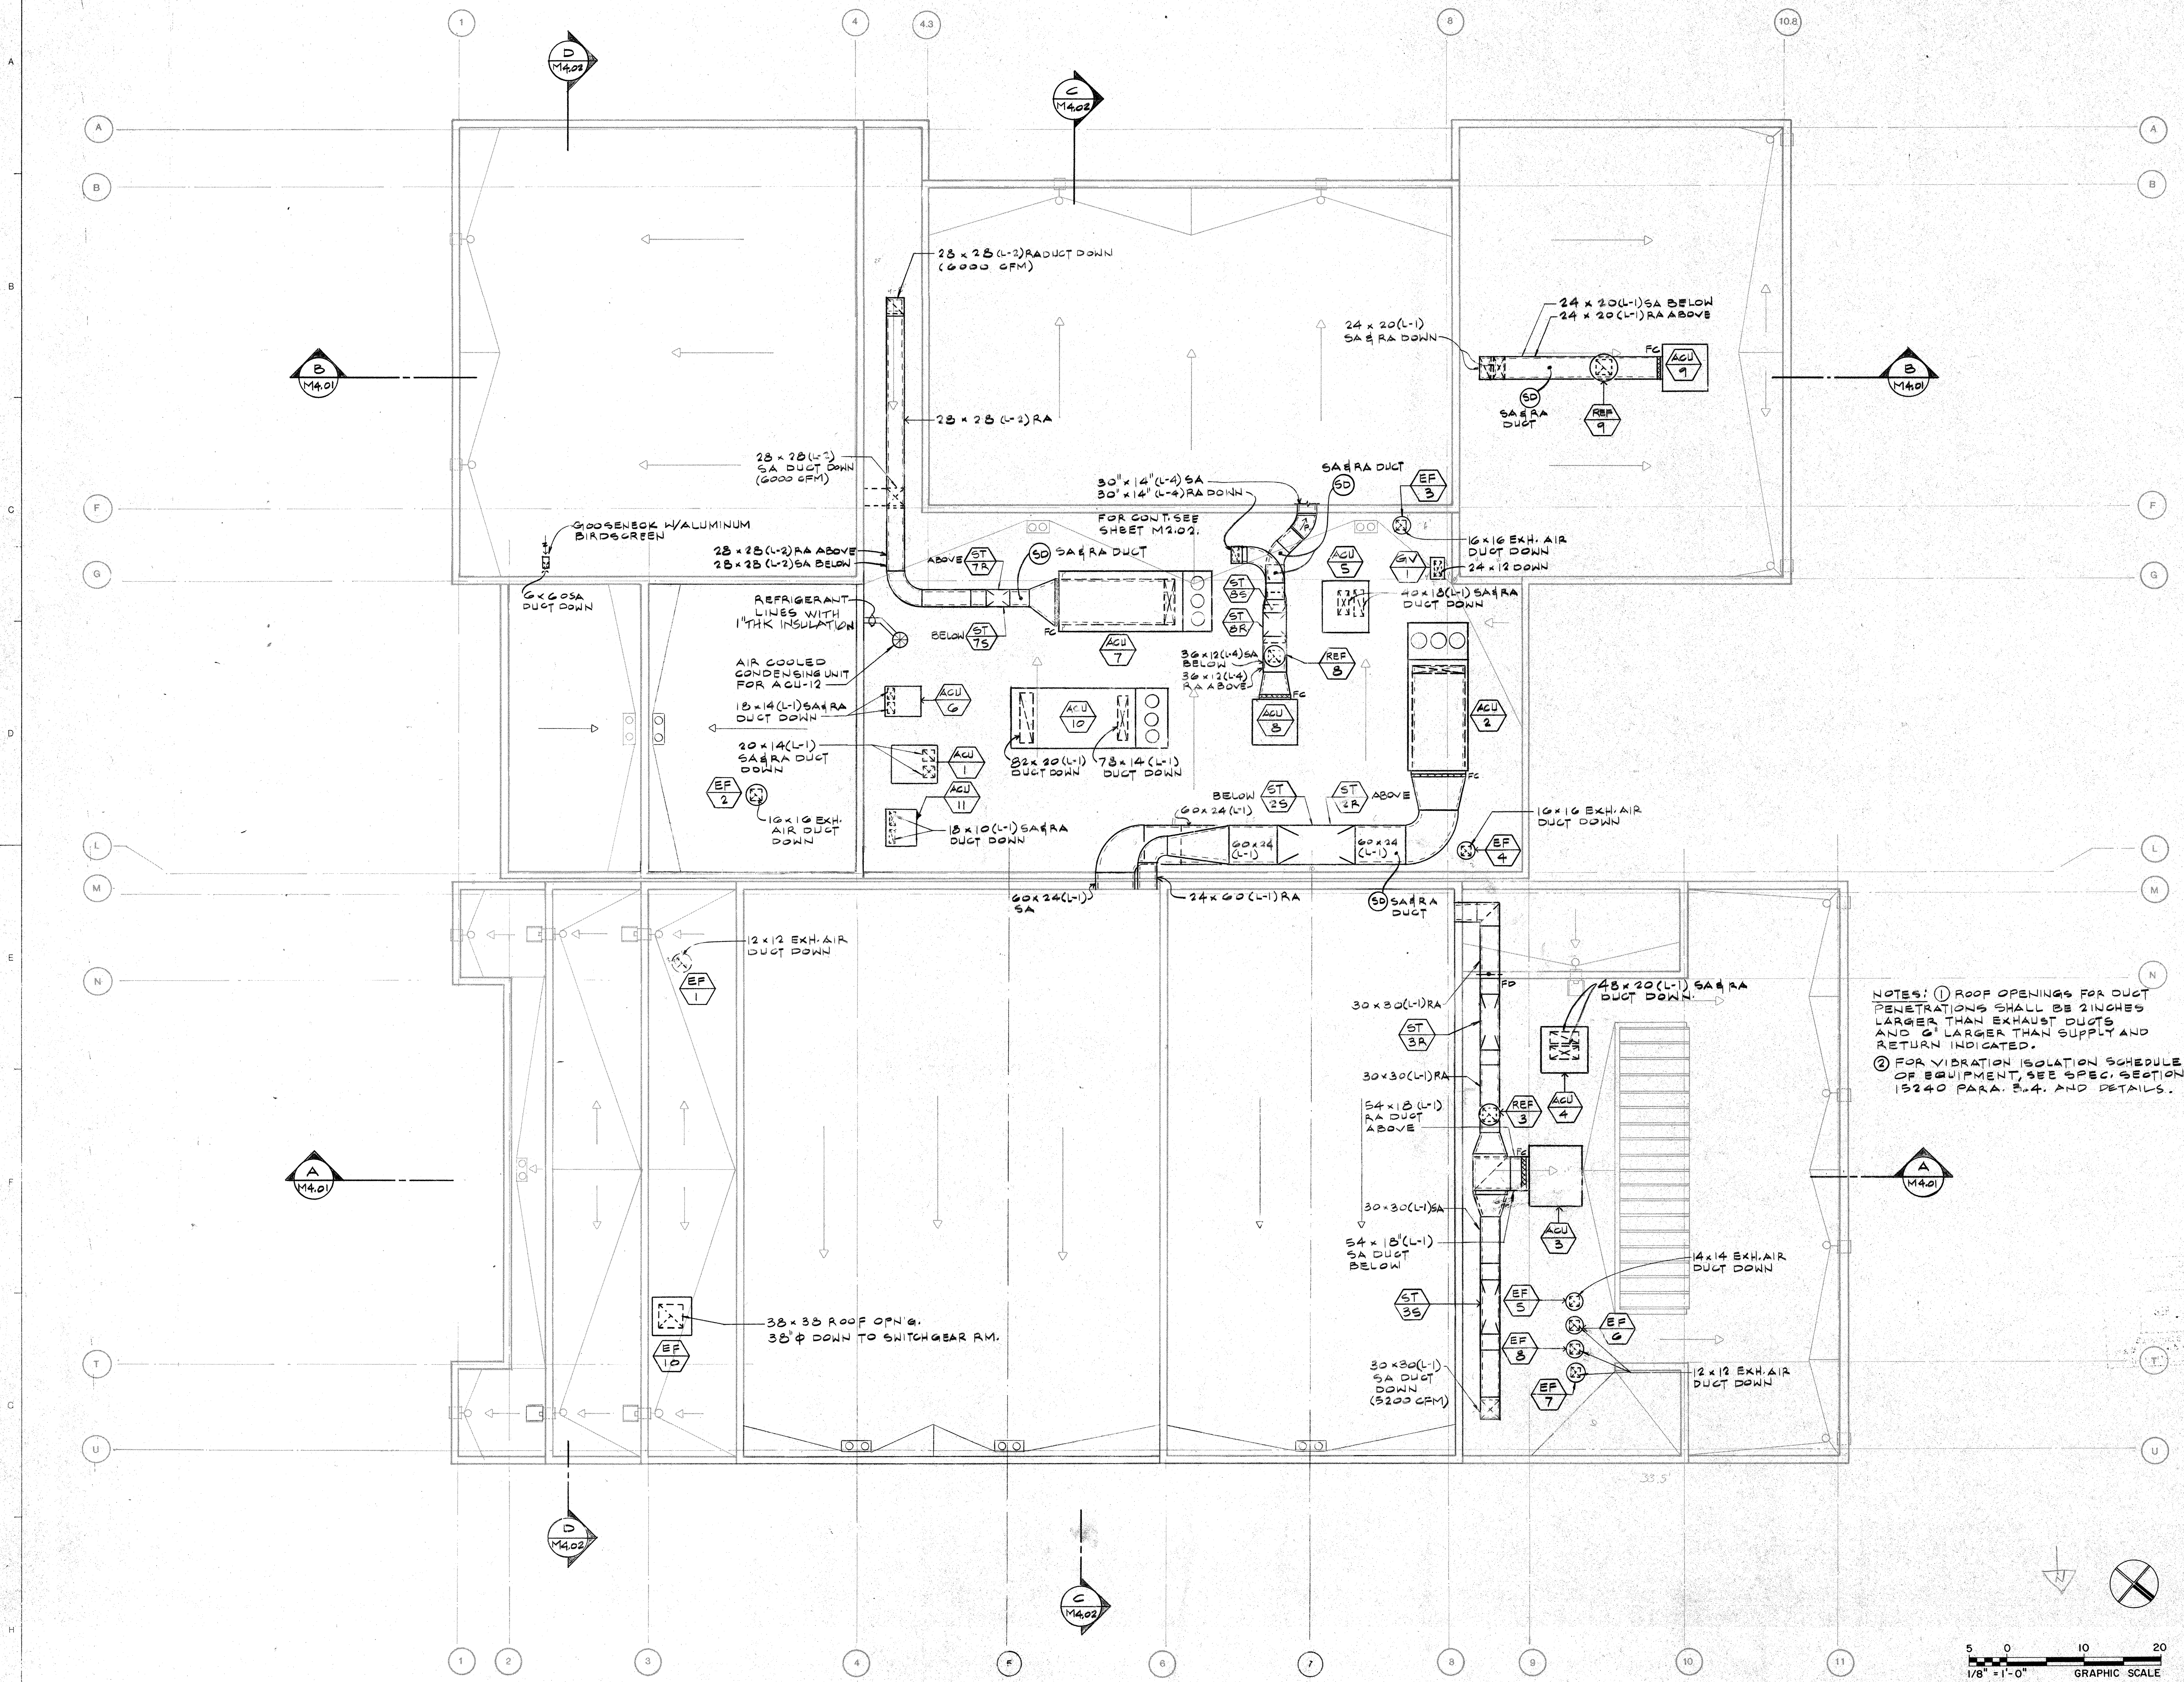

NOTES: ① ROOF OPENINGS FOR DUCT PENETRATIONS SHALL BE 2 INCHES LARGER THAN EXHAUST DUCTS AND 6" LARGER THAN SUPPLY AND RETURN INDICATED.
 ② FOR VIBRATION ISOLATION SCHEDULE OF EQUIPMENT, SEE SPEC. SECTION 15240 PARA. 3.4.4. AND DETAILS.

O.S.A. SUBMITTAL #1 NOV. 22 1991
 REVISIONS

SIGNATURE

O.S.A. APPROVAL
 STATE FIRE MARSHALL ACCESS COMPLIANCE

SEP 3 1992
 STATE FIRE MARSHALL
 SOUTHERN REGION

STRUCTURAL SAFETY
 IDENTIFICATION STAMP
 Department of General Services
 Office of the State Architect
 SEP 3 1992
 Structural Safety Society
 Approved by: 57288
 Batchchecked by: JTC


SHEET TITLE
ROOF PLAN

CHECKED BY APPROVED BY


JOB NO. **1149.01**

DATE

M2.05

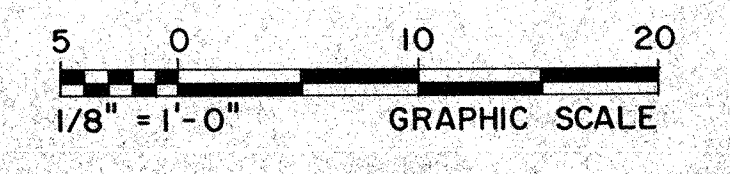

PROJECT

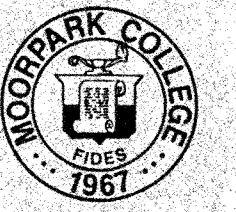

MOORPARK COLLEGE PERFORMING ARTS CENTER

CLIENT

VENTURA COUNTY
 COMMUNITY COLLEGE DISTRICT


71 Day Road
 Ventura, California 93003

ACOUSTICAL ENGINEERS


McKAY, CONANT, BROOK, INC.
 5655 Lindero Canyon Road
 Suite 325
 Westlake Village, California 91362
 PHONE: (818) 991-9300

THEATER CONSULTANT

LANDRY & BOGAN
 2513 Charleston Road, Suite B
 Mountain View, California 94043
 PHONE: (415) 969-5195

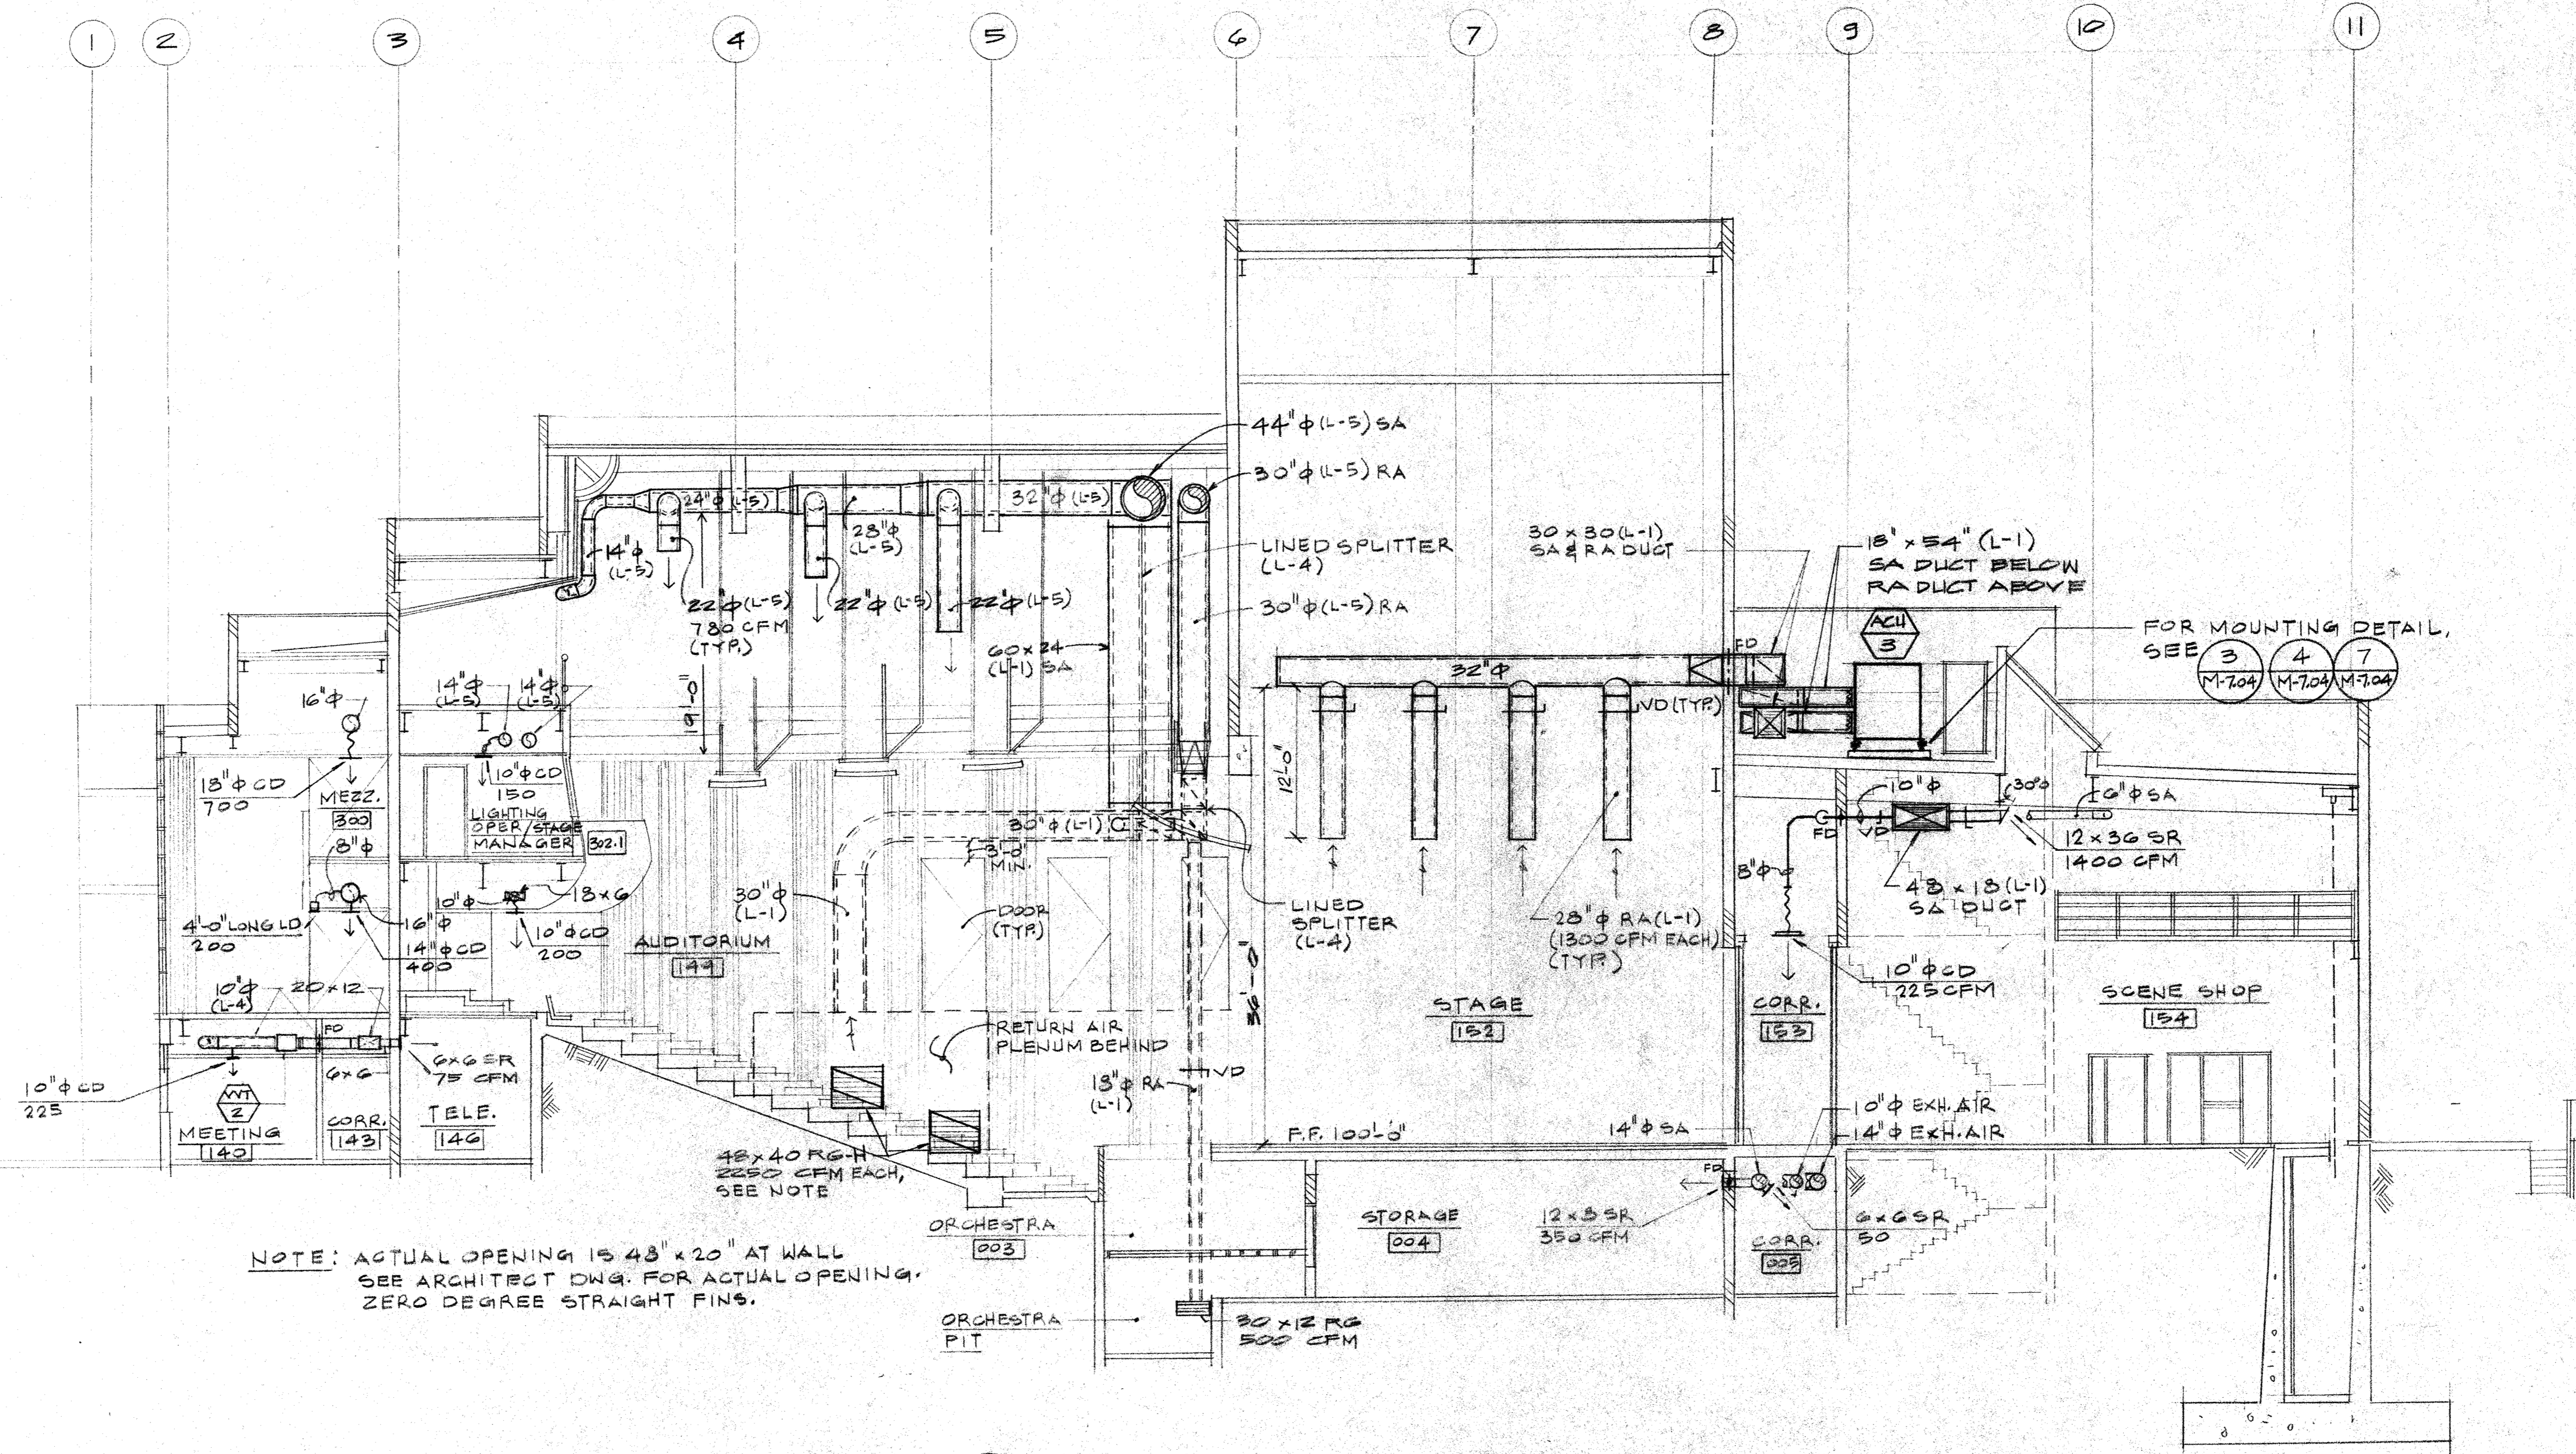

A SECTION
 M4.01 1/8"=1'-0"

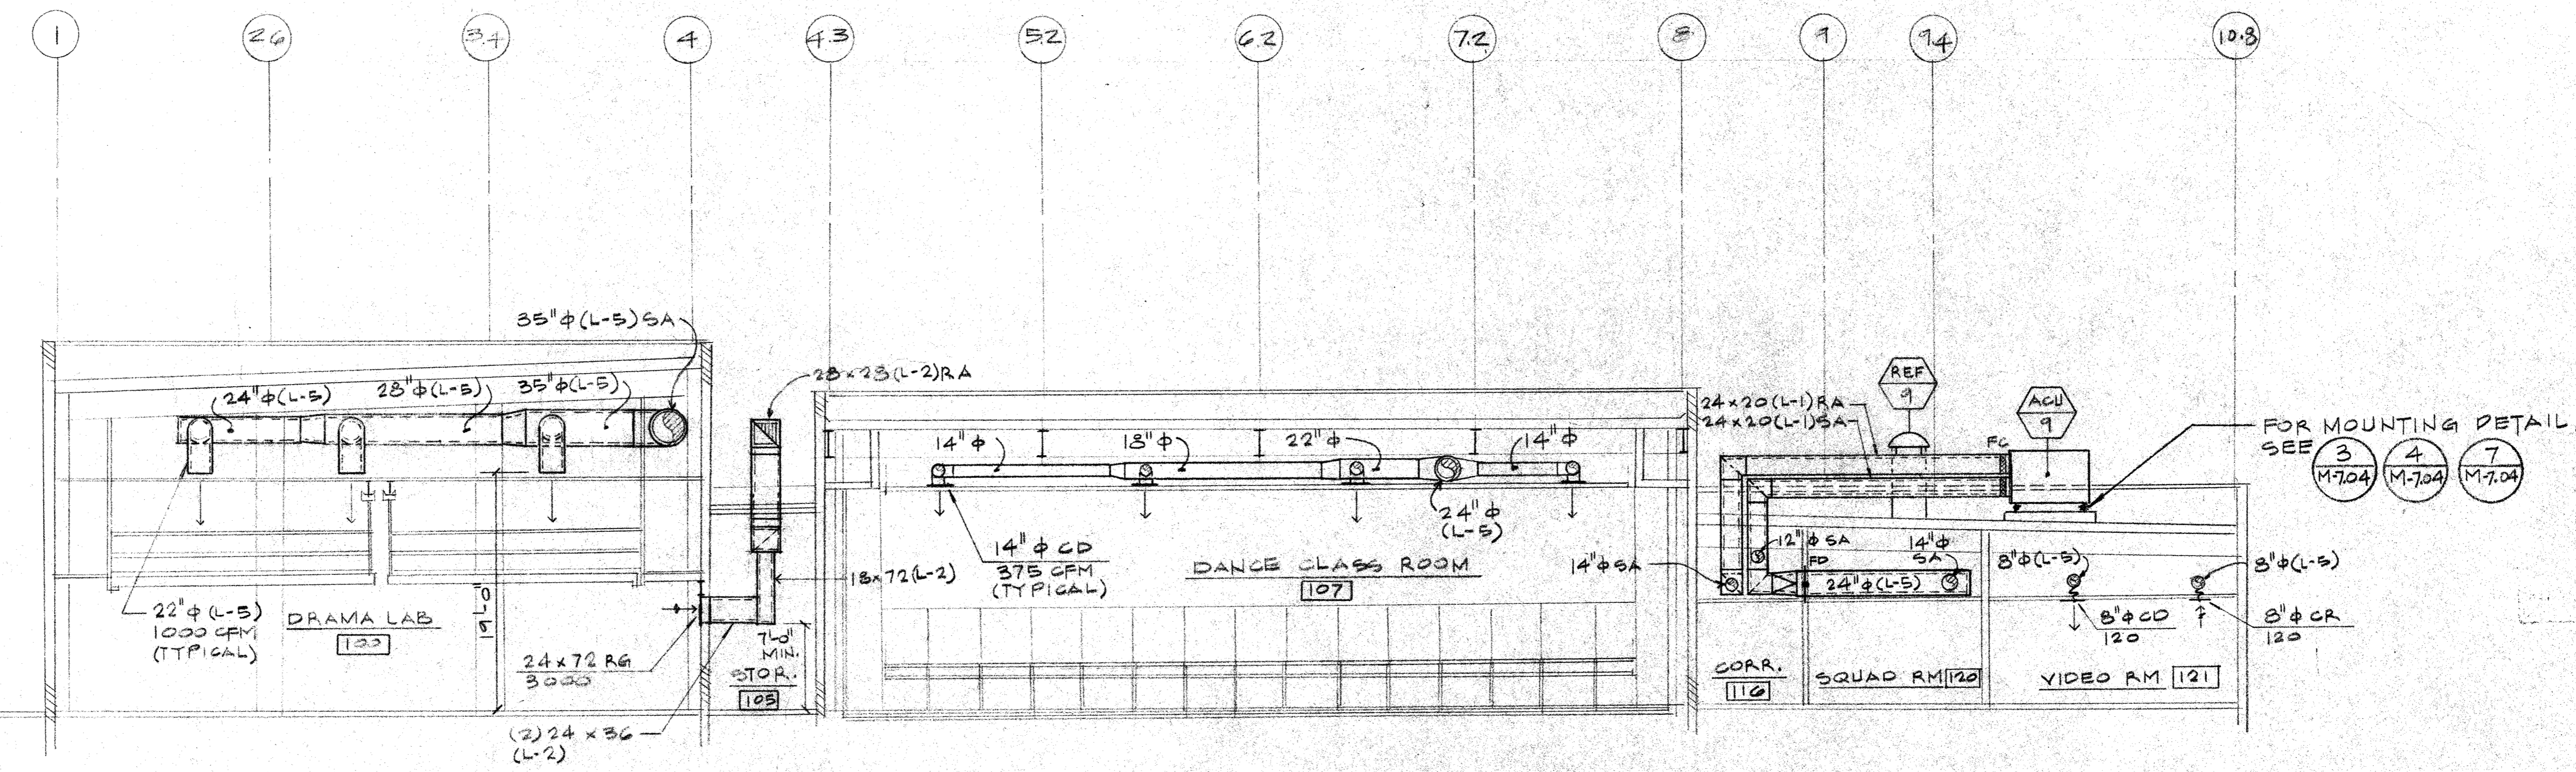


B SECTION
 M4.01 1/8"=1'-0"

O.S.A. SUBMITAL #1 NOV. 22 1991


REVISIONS

SIGNATURE

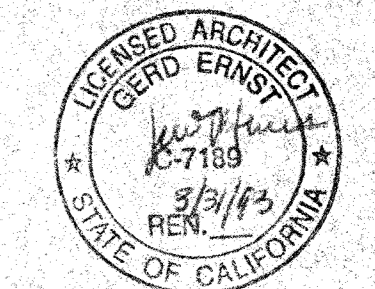


O.S.A. APPROVAL

STATE FIRE MARSHALL ACCESS COMPLIANCE

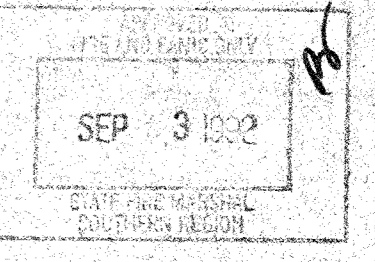

STRUCTURAL SAFETY

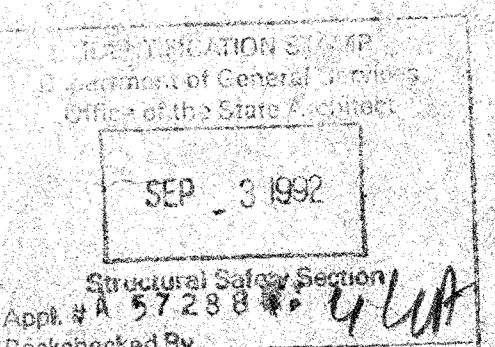

SHEET TITLE

SECTIONS

CHECKED BY APPROVED BY

JOB NO. 1149.01

DATE

M4.01